


POPEYES LOUISIANA KITCHEN

929 HARD ROAD * TOWN OF WEBSTER * COUNTY OF MONROE

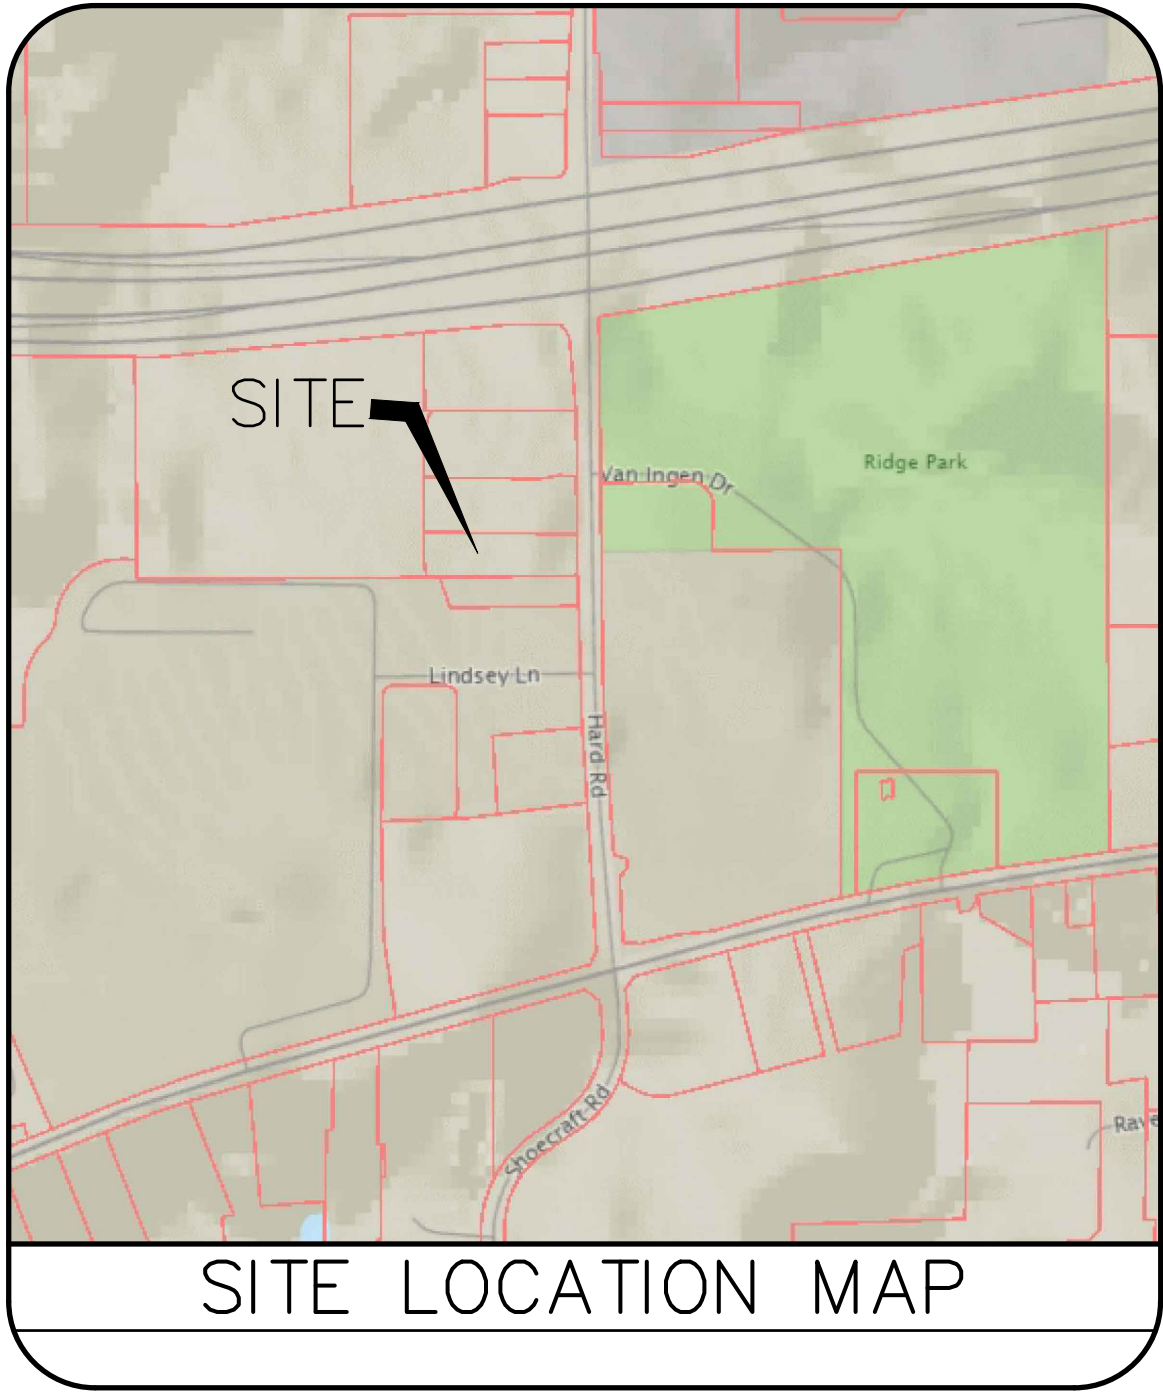

LEGEND	
SHEET	DESCRIPTION
S-1	BOUNDARY AND TOPOGRAPHIC SURVEY
C-1	SITE PLAN
C-2	GRADING PLAN
C-3	UTILITY PLAN
C-4	LANDSCAPING PLAN
C-5	E & SC PLAN
D-1	DETAILS
D-2	DETAILS
D-3	DETAILS
L-1	LIGHTING PLAN

DATE: OCTOBER 17, 2023
LAST REVISED: 12/15/23
2/5/24
2/23/24
4/17/24


APPROVALS

DIRECTOR OF COMMUNITY DEVELOPMENT _____ DATE _____
PLANNING BOARD CHAIRPERSON _____ DATE _____
FIRE MARSHALL _____ DATE _____
TOWN OF WEBSTER SEWER DISTRICT _____ DATE _____
TOWN ENGINEER _____ DATE _____
TOWN OF WEBSTER HIGHWAY SUPERINTENDENT _____ DATE _____
TOWN OF WEBSTER ASSESSOR _____ DATE _____
MONROE COUNTY WATER AUTHORITY _____ DATE _____

APPLICANT:
LIBERTY RESTAURANTS HOLDINGS
252-25 UNION TURNPIKE
BELLROSE, NY 11426
(917) 495-1560
LADDI@LRHOLDINGS.US



PREPARED BY:
BRETT L. STEENBURGH, P.E. LLC

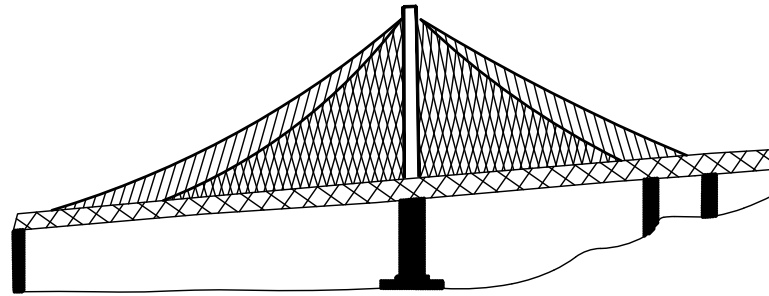

2832 ROSENDALE ROAD
NISKAYUNA, NY 12309
(518) 365-0675
bsteenburghpe@yahoo.com

CIVIL ENVIRONMENTAL STRUCTURAL

North Per Map Reference

MAP REFERENCES:

1. MAP ENTITLED, "RESUBDIVISION OF WEBSTER SQUARE PHASE 1 LOT AR-10" DATED JANUARY 5, 2010 PREPARED BY KEVIN M. SULLIVAN, L.S. AND FILED IN THE MONROE COUNTY CLERK'S OFFICE AS MAP NO. 23542.
2. MAP ENTITLED, "FINAL PLAN A RESUBDIVISION OF LOT AR-4A-3 WEBSTER SQUARE PHASE 1" DATED MAY 1, 2015 PREPARED BY MARQUESS & ASSOCIATES, P.C. LAND SURVEYING ENGINEERING AND FILED IN THE MONROE COUNTY CLERK'S OFFICE AS MAP NO. 24756.

NOTES:

1. THIS SURVEY WAS PERFORMED WITHOUT THE BENEFIT OF AN UP TO DATE ABSTRACT OF TITLE AND/OR TITLE REPORT AND MAY BE SUBJECT TO WHATEVER STATEMENT OF FACTS THEY MAY REVEAL.
2. NO ATTEMPT WAS MADE TO SHOW UNDERGROUND IMPROVEMENTS IN THE PREPARATION OF THIS SURVEY.
3. ONLY BOUNDARY SURVEY MAPS WITH THE SURVEYOR'S EMBOSSED SEAL ARE GENUINE TRUE AND CORRECT COPIES OF THE SURVEYOR'S ORIGINAL WORK AND OPINION.
4. COPYRIGHT © 2024 BY GILBERT VANGUILDER LAND SURVEYOR, PLLC. ALL RIGHTS RESERVED. REPRODUCTION OR COPYING OF THIS DOCUMENT MAY BE A VIOLATION OF COPYRIGHT LAW UNLESS PERMISSION OF THE AUTHOR AND/OR COPYRIGHT HOLDER IS OBTAINED.
5. OFFSETS OR DIMENSIONS FROM THE PROPERTY LINE TO STRUCTURES OR IMPROVEMENTS ARE SHOWN FOR THE PURPOSE TO POSITION IT RELATIVE TO THE PROPERTY LINE AND/OR COMPLIANCE WITH ZONING, AND ARE NOT INTENDED TO MONUMENT THE PROPERTY LINES OR GUIDE IN THE ERECTION OF FENCES OR OTHER IMPROVEMENTS TO THE LAND.
6. THE HORIZONTAL DATUM SHOWN HEREON IS REFERENCED TO THE NEW YORK STATE PLANE COORDINATE SYSTEM, TRAVERSE MERCATOR PROJECTION, (NAD 27) WESTERN ZONE PER MAP REFERENCES.

Lands N/F Of
WWM WEBSTER COMPANY I, LLC
Book 11329 Of Deeds At Page 622
Tax Parcel 79.11-1-12.11
925 Hard Road

Lands N/F Of
HEGEDORN PLAZA LLC
Book 10413 Of Deeds At Page 78
Tax Parcel 79.11-1-21.11


Lot BR-4A-3B
(See Map Ref. No. 2)

Lot BR-1BB
(See Map Ref. No. 1)

Lands N/F Of
HARD ROAD, LLC
Book 12484 Of Deeds At Page 141
Tax Parcel 79.15-1-1.312
950 Ridge Road

Lands N/F Of
HARD ROAD, LLC
Book 12484 Of Deeds At Page 141
Tax Parcel 79.15-1-1.312
950 Ridge Road

UNAUTHORIZED ALTERATIONS OR ADDITIONS TO THIS SURVEY MAP IS A VIOLATION OF SECTION 7209 OF THE NEW YORK STATE EDUCATION LAW. ONLY COPIES OF THIS SURVEY MAP BEARING THE LAND SURVEYOR'S ORIGINAL SIGNATURE AND EMBOSSED SEAL SHALL BE CONSIDERED VALID.

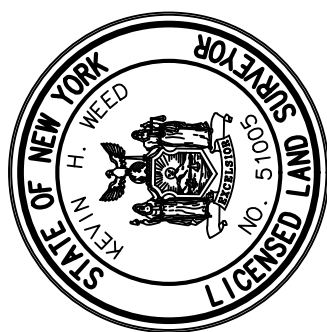

KEVIN H. WEED, P.L.S. No. 51005

**TOPOGRAPHIC SURVEY
LOT BR-4A-3B &
LOT BR-1BB**

TOWN OF WEBSTER
MONROE COUNTY, NEW YORK
MAP NUMBER: 24 - 30 - 42
SCALE: 1" = 20'


DATE: FEBRUARY 5, 2024

Gilbert VanGuilder
Land Surveyor, PLLC

Professional Land Surveyors
988 Route 146, Clifton Park, New York 12065
Telephone: (518) 383-0634
gvglandsurveyors.com

S-1

Printed Under - 2/5/24

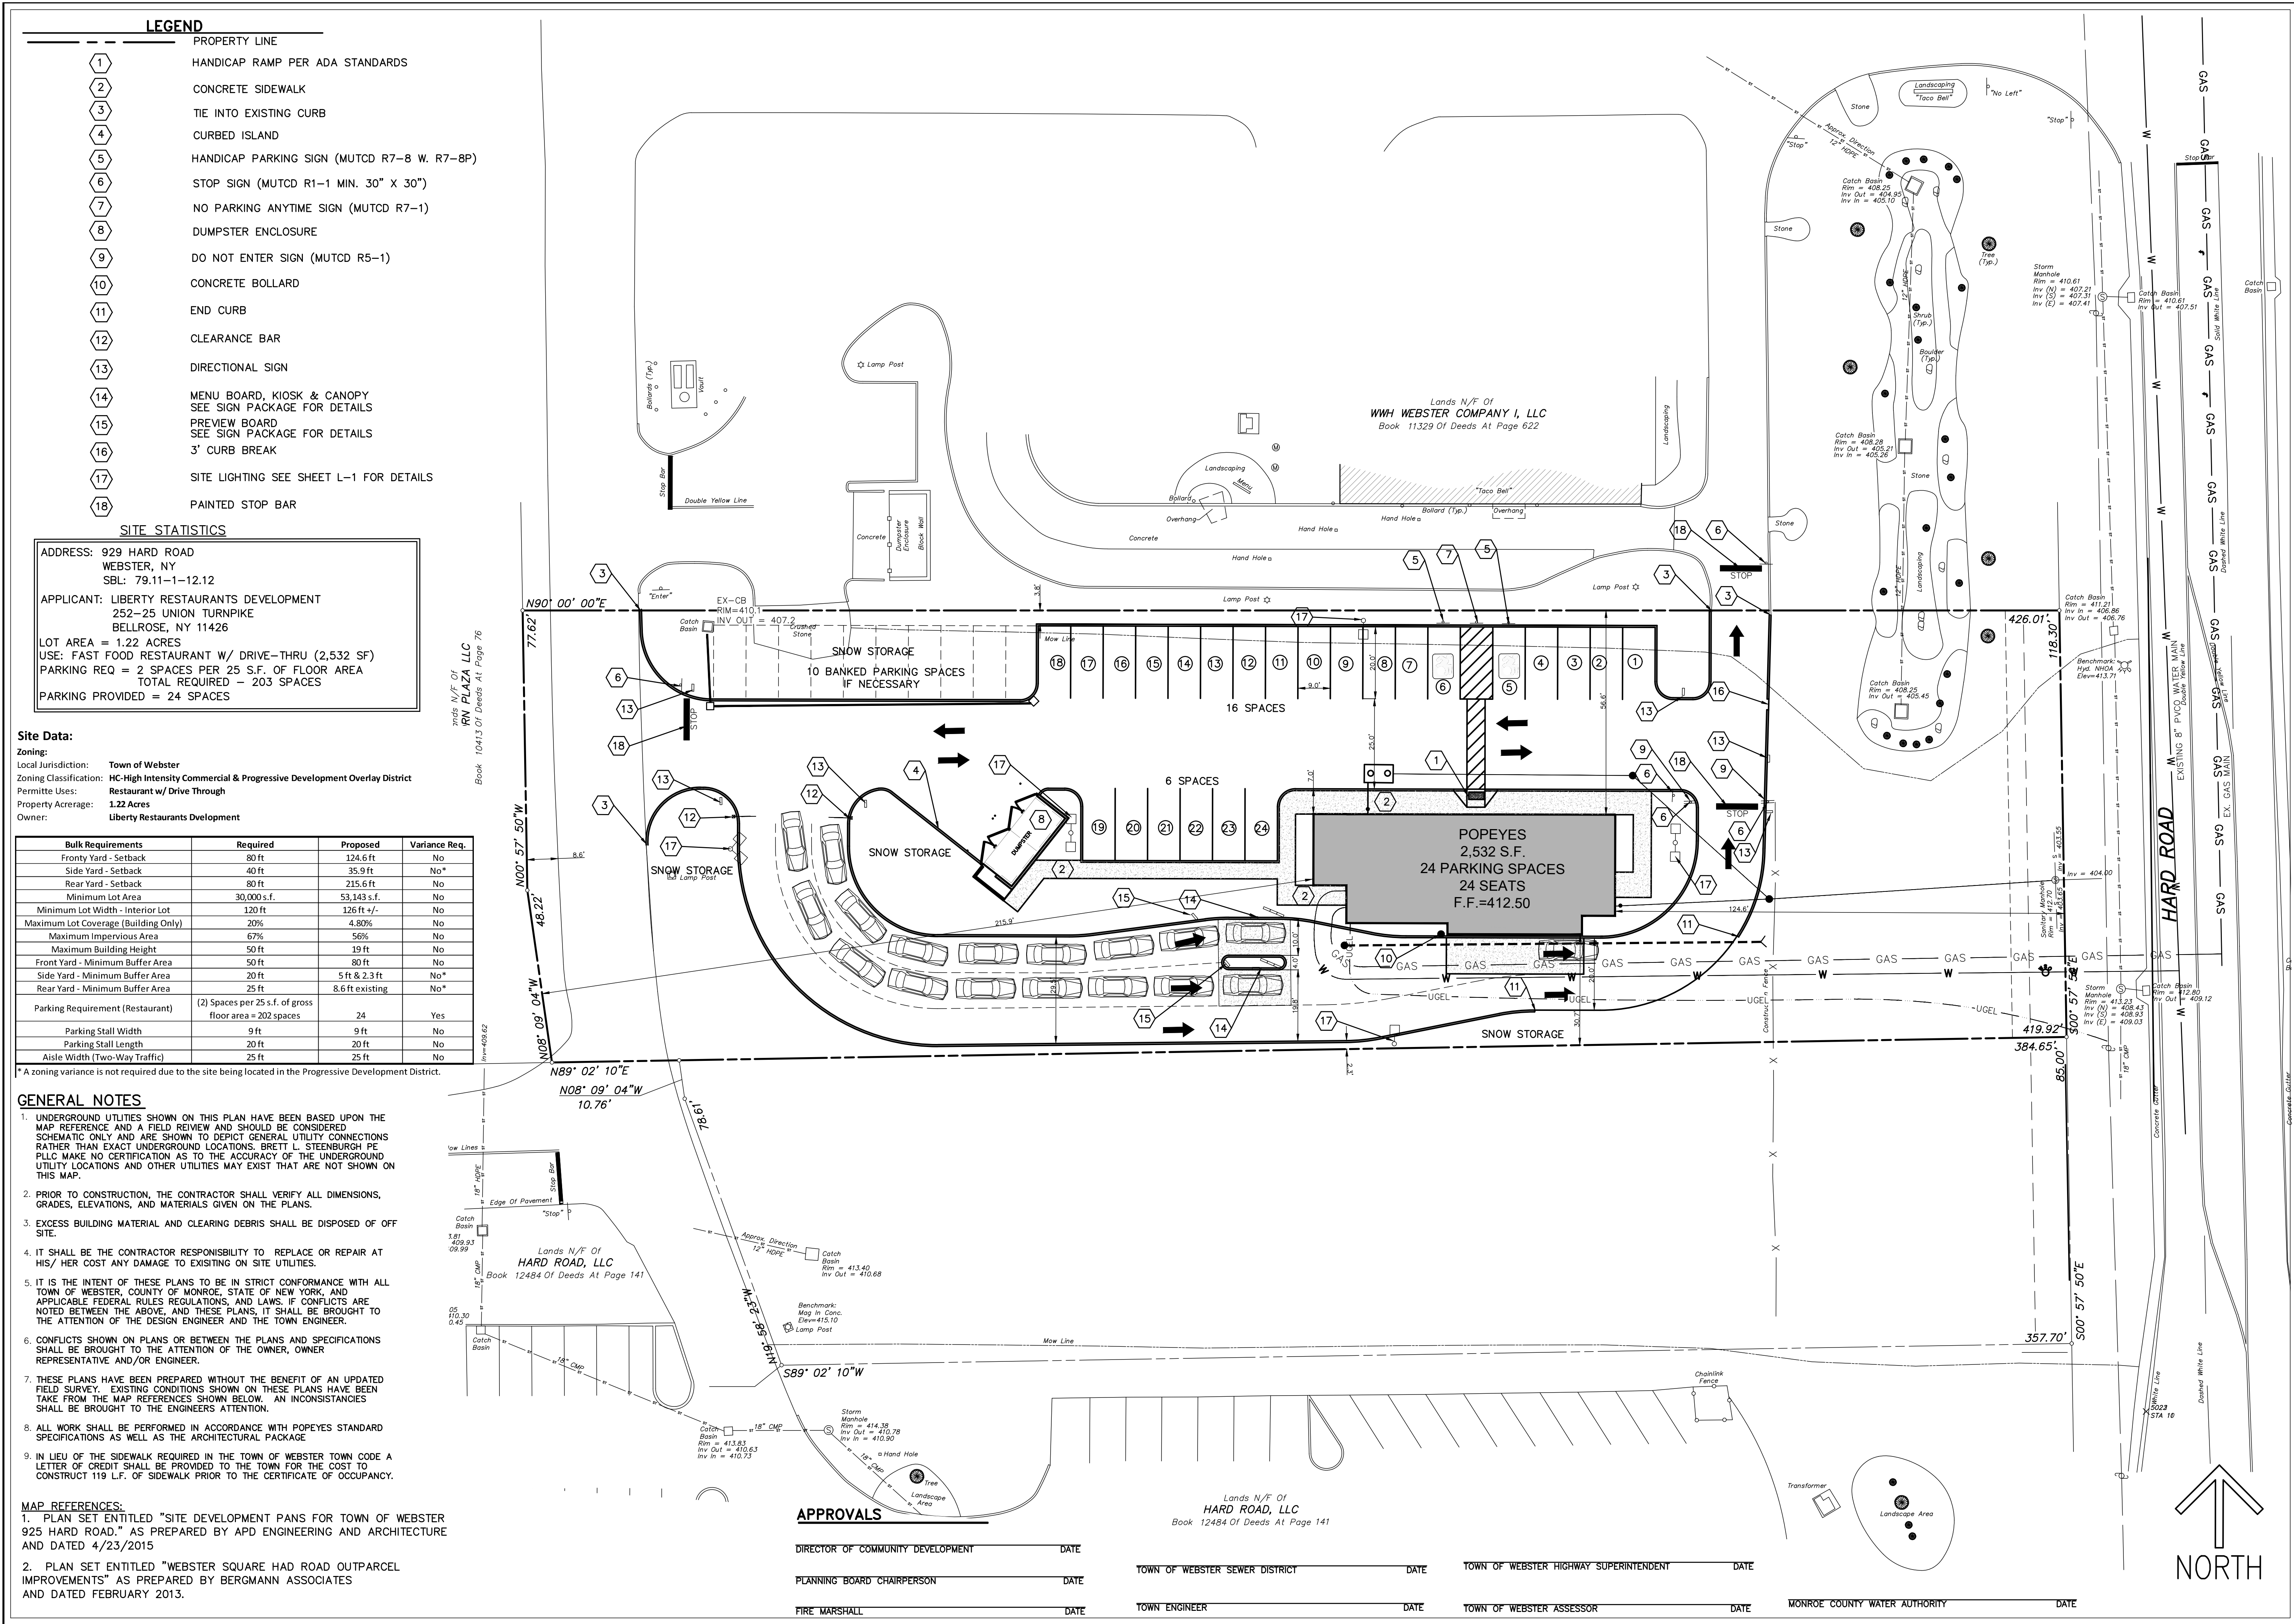

BRETT L. STEENBURGH, P.E. PLLC

2832 Rosendale Road
Niskayuna, NY 12309
(518) 365-0875
bsteenburgpe@gmail.com

**ENGINEERING THAT TRANSFORMS
IMAGINATION INTO REALITY**

SITE PLAN
LIBERTY RESTAURANTS
HARD ROAD

COUNTY OF MONROE
TOWN OF WEBSTER

CHECKED BY: [Signature]
JOB NO. [Number]

SCALE: 1" = 20'
SHEET C-1

DATE: OCTOBER 17, 2023

Call 811
before you dig

Scaling off these drawings shall be done only for review and approval purposes. Contractors are not to scale these drawings for layout and construction.

Unauthorized alterations or additions to these drawings are prohibited. Any such alterations or additions shall be the responsibility of the person making such alterations or additions. The user of these drawings shall be responsible for obtaining all necessary permits and approvals for the project. The user of these drawings shall be responsible for obtaining all necessary permits and approvals for the project.

Copyright 2021 Brett L. Steenburgh, P.E. PLLC
Sub. 2 of the NYS Education Law
Copyright 2021 Brett L. Steenburgh, P.E. PLLC
Sub. 2 of the NYS Education Law
Copyright 2021 Brett L. Steenburgh, P.E. PLLC
Sub. 2 of the NYS Education Law


LEGEND	
	PROPERTY LINE
	PROPOSED CONTOUR
	EXISTING CONTOUR
	PROPOSED SPOT ELEVATION
	PROPOSED DRAINAGE FLOW ARROW

GRADING & DRAINAGE NOTES

- ALL STRUCTURES SHALL HAVE GUTTERS CONSTRUCTED ON THEM. THE GUTTERS SHALL DISCHARGE EITHER DIRECTLY TO THE STORM SEWER OR IN SUCH A WAY TO PROVIDE POSITIVE DRAINAGE TO THE STORM SEWERS.
- UNDER NO CIRCUMSTANCES SHALL ANY RUNOFF FROM A CONSTRUCTED IMPERVIOUS SURFACE BE DISCHARGED DIRECTLY TO THE ON SITE WETLANDS.
- THE MAXIMUM SLOPE SHALL BE A 3 HORIZONTAL TO 1 VERTICAL.
- A POSITIVE SLOPE SHALL BE MAINTAINED AWAY FROM ALL STRUCTURES.

MAP REFERENCES:

- PLAN SET ENTITLED "SITE DEVELOPMENT PANS FOR TOWN OF WEBSTER 925 HARD ROAD," AS PREPARED BY APD ENGINEERING AND ARCHITECTURE AND DATED 4/23/2015
- PLAN SET ENTITLED "WEBSTER SQUARE HARD ROAD OUTPARCEL IMPROVEMENTS" AS PREPARED BY BERGMANN ASSOCIATES AND DATED FEBRUARY 2013.

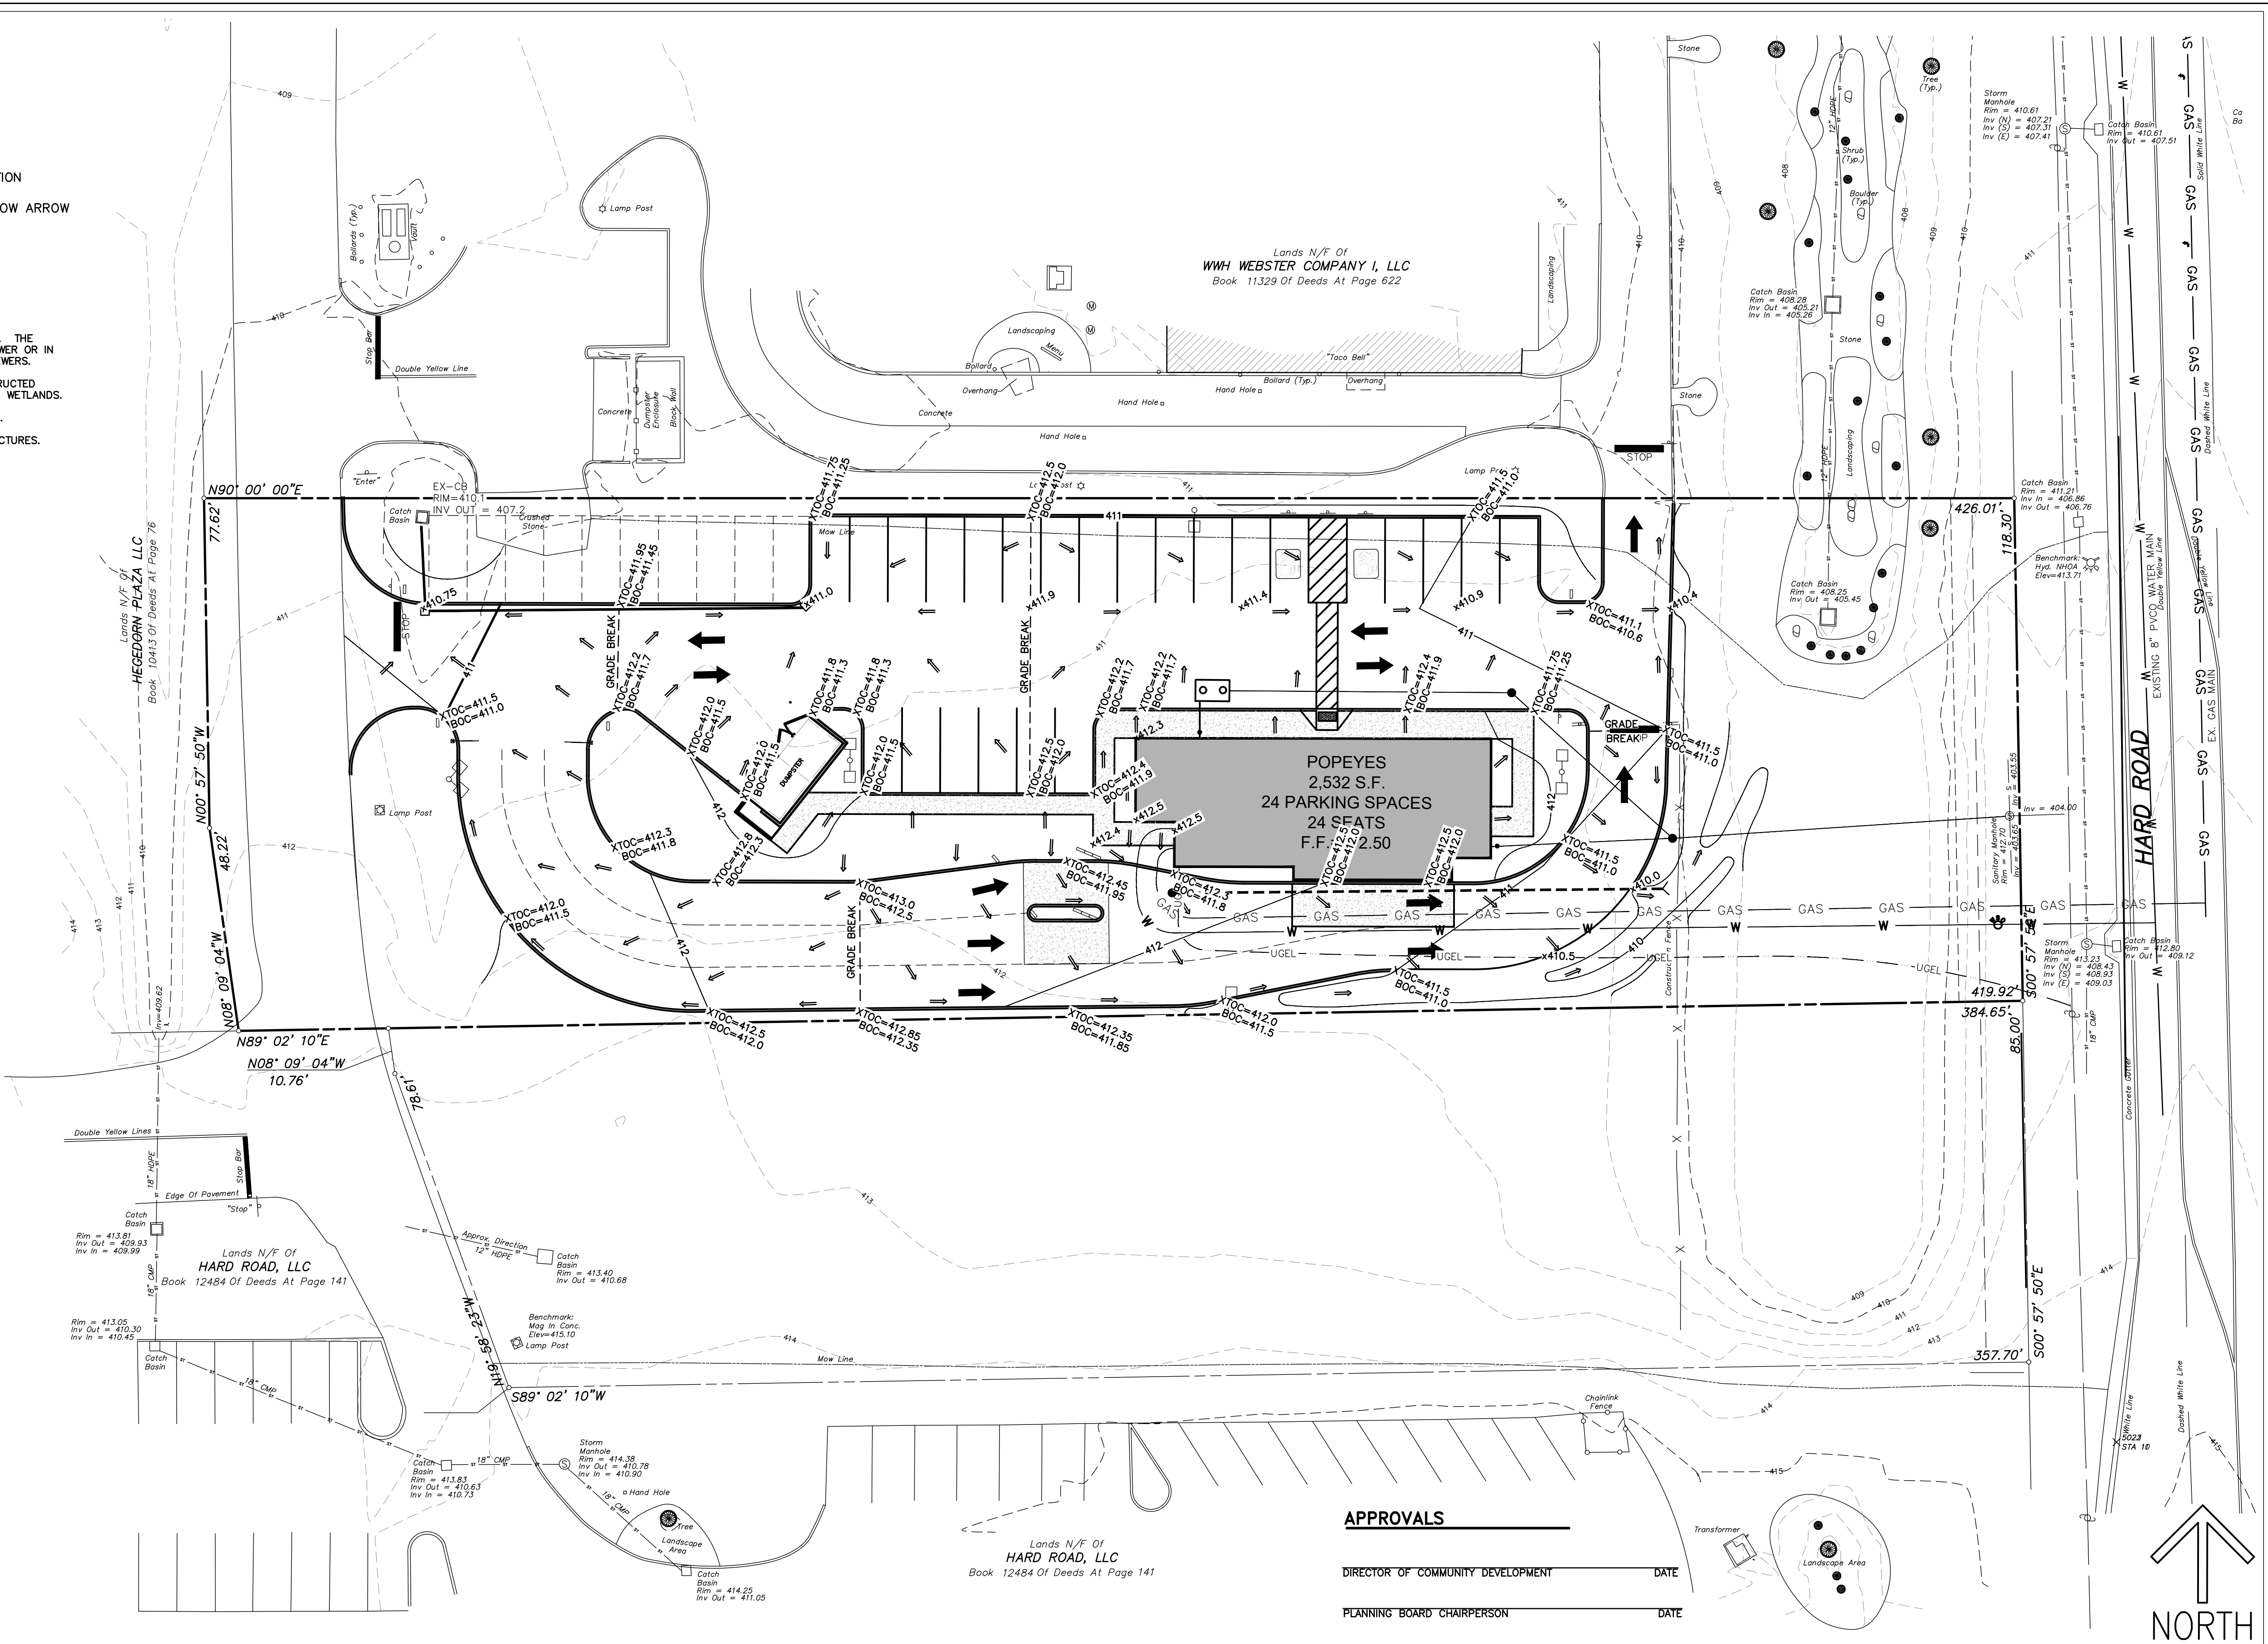

APPROVALS

DIRECTOR OF COMMUNITY DEVELOPMENT	DATE
PLANNING BOARD CHAIRPERSON	DATE
FIRE MARSHALL	DATE
TOWN OF WEBSTER SEWER DISTRICT	DATE
TOWN ENGINEER	DATE
TOWN OF WEBSTER HIGHWAY SUPERINTENDENT	DATE
TOWN OF WEBSTER ASSESSOR	DATE
MONROE COUNTY WATER AUTHORITY	DATE

BRETT L. STEENBURGH, P.E. PLLC

2832 Rosendale Road
Niskayuna, NY 12309
(518) 365-0875
bsteenburgpe@gmail.com

**ENGINEERING THAT TRANSFORMS
IMAGINATION INTO REALITY**


GRADING PLAN
LIBERTY RESTAURANTS
HARD ROAD

COUNTY OF MONROE	STATE OF NEW YORK	SHEET C-2
DRAWN BY: BLS	CHECKED BY:	SCALE: 1" = 20'
CADD FILE:	JOB NO.	
DATE:		

OCTOBER 17, 2023

Scaling of these drawings shall be done only for review and approval purposes. Contractors shall not scale drawings for electronic data only for layout and construction.

Unauthorized alterations or additions to these drawings are prohibited. Any use of these drawings without the express written consent of Brett L. Steenburgh, P.E., PLLC is prohibited.

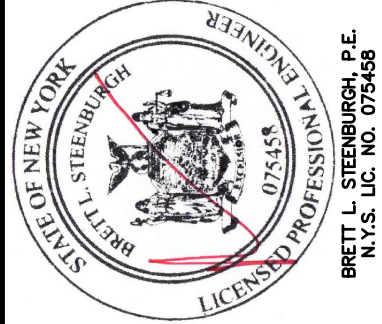

Call 811
before you dig

1-800-4-A-DAIRY

NO.	DATE	REVISIONS	BY:
1	12/26/23	REVISED AS PER THE COMMENTS	
2	2/23/24	REVISED AS PER THE COMMENTS	
3	4/17/24	ADDED HYDRAULIC DATA	
4	4/17/24	ADDED HYDRAULIC DATA	

STANDARD NOTES

- "ALL UTILITIES TO BE INSTALLED IN ACCORDANCE WITH TOWN OF WEBSTER STANDARDS AND SPECIFICATIONS. PRIOR TO CONSTRUCTION.
- "ALL ELEVATIONS SHOWN ARE ON USGS ELEVATION BASE."
- "PRIOR TO ANY WORK ON SANITARY SEWER AND WATER, THE CONTRACTOR SHALL OBTAIN THE NECESSARY PERMITS FROM THE TOWN OF WEBSTER."
- "ALL CONTROLLED FILL SHALL BE CERTIFIED BY A LICENSED SOILS ENGINEER, THAT PLACEMENT OF THE MATERIAL WAS DONE IN A MANNER SUITABLE FOR THE CONSTRUCTION OF THE ROAD AND THE INSTALLATION OF WATERMAIN, STORM SEWERS, AND SANITARY SEWERS. TO THIS END, NO FILL SHALL BE PLACED IN AREAS IDENTIFIED ON THESE PLANS AS CONTROLLED FILL AREAS UNTIL THE CERTIFYING SOILS ENGINEER HAS BEEN CONSULTED."

WATER SUPPLY NOTES

- ALL WATER SERVICES SHALL BE TYPE K COPER
- THE WATERMAIN SHALL BE PRESSURE TESTED AT 150 PSI FOR 2 HOURS. THE ALLOWABLE LEAKAGE FOR 18 FT. OF LAYING LENGTH OF PIPE IS 0.74 GAL/2 HOURS/1000 FT. OF PIPE.
- THE WATERMAIN SHALL BE DISINFECTED WITH A WATER AND CHLORINE SOLUTION WITH A MINIMUM OF 50PPM CHLORINE. THE CHLORINE RESIDUAL IS TO BE A MINIMUM OF 25PPM AFTER 24 HOURS. THE WATERMAIN SHALL THEN BE FLUSHED AND A SAMPLE TAKEN FOR BACTERIA TESTING PRIOR TO BEING PLACED IN SERVICE. DISINFECTION SHALL BE PERFORMED IN ACCORDANCE WITH AWWA C651-99 CONTINUOUS FEED METHUEN PROCEDURE IN AWWA C651 STANDARDS REQUIRED FOR POTABLE WATER SHALL BE MET. CHLORINATION AFTER A 24 HOUR HOLDING PERIOD IN THE MAIN SHALL HAVE A FREE CHLORINE RESIDUAL OF NOT LESS THAN 10 MG/L.
- WATERMAINS AND SEWERS SHALL BE LOCATED SUCH THAT AN 18 INCH VERTICAL SEPARATION IS MAINTAINED AT POINTS WHERE THEY CROSS. ALSO, A 10 FT. HORIZONTAL DISTANCE BETWEEN THE TWO MUST BE MAINTAINED IN AREAS WHERE THEY RUN PARALLEL. AT CROSSINGS, ONE FULL LENGTH OF WATER PIPE SHALL BE LOCATED SO THAT BOTH JOINTS WILL BE AS FAR FROM THE SEWER AS POSSIBLE.
- WATERWORKS ARE TO BE CONSTRUCTED IN ACCORDANCE WITH ALL FEDERAL, STATE, AND LOCAL STANDARDS AND SPECIFICATIONS.
- MATERIALS SHALL COMPLY WITH THE FOLLOWING:
D.I.P. - AWWA C151/A21.51-02
FITTINGS - AWWA C104/A21.4-03
VALVES - AWWA C500-02
FIRE HYDRANTS - AWWA C502-94
- PRESSURE AND LEAKAGE TESTS MUST BE PERFORMED ON THE WATER SYSTEM AND RESULTS MUST CONFORM TO AWWA C600 STANDARDS. PRESSURE DURING THE TEST SHALL NOT VARY BY MORE THAN 5 PSI. THE MAXIMUM ALLOWABLE LEAKAGE FOR EACH TEST SECTION OF D.I.P. IS DETERMINED BY THE FORMULA ($L = 150 \sqrt{SP} P$) OVER 1133,200). (WHERE L=LEAKAGE (GAL/HR), S=LENGTH (FT), D=PIPE DIA. (IN), P=AVERAGE TEST PRESSURE (PSI))
- ALL WATERMAIN INSTALLATION SHALL COMPLY WITH AWWA C600-99
- ALL WATER SERVICES SHALL COMPLY WITH FEDERAL, STATE AND LOCAL BUILDING CODES
- ALL WATER SERVICES SHALL BE METERED. METERS SHALL BE PROVIDED BY THE MCWA AT THE DEVELOPERS COST.
- IF CONTAMINATED GROUNDWATER IS ENCOUNTERED ANY TIME DURING THE CONSTRUCTION, NON PERMIABLE PIPE, JOINTS, HYDRANTS AND AND SERVICE CONNECTIONS SHALL BE USED IN THE AREA OF CONTAMINATION.
- SAMPLING REQUIREMENTS
1ST DAY - TOTAL COLIFORM AND HETATROPHIC
2ND DAY - TOTAL COLIFORM
- WATER MAINS SHALL NOT BE BROUGHT INTO SERVICE UNTIL THE COMPLETED WORKS IS ISSUED.

SANITARY SEWER NOTES

- INSTALLATION:
- ALL GRAVITY SEWER PIPE SHALL BE SDR-26 P.V.C.
- INSTALLATION SHALL BE PERFORMED IN ACCORDANCE WITH THESE PLANS AND ALL APPLICABLE MANUFACTURERS SPEC.
- BEDDING AND BACKFILL MATERIAL SHALL BE COMPACTED TO A MINIMUM OF 95% OF THE STANDARD PROCTOR DENSITY.
- DOMESTIC WASTEWATER SHALL NOT BE TIED INTO THE GREASE TRAP
 - THE SANITARY SEWER LATERAL SHALL BE AIR TESTED AND MANDREL TESTED FROM THE BUILDING CLEANOUT TO CONNECTION MANHOLE
 - THE TOWN OF WEBSTER SEWER DEPARTMENT WILL COMPLETE A VIDEO INSPECTION OF THE SANITARY LATERALS AT THE C OF O INSPECTION.
 - ALL KITCHEN FLOOR DRAINS SHALL BE CONNECTED TO THE GREASE LATERAL AND GREASE TRAP.

SANITARY SEWER TESTING

AIR TEST:

AIR TEST ALL SEWER PIPE, INCLUDING LATERALS, IN CONFORMANCE WITH ASTM F1417.

TEST PRESSURES SPECIFIED SHALL BE COMMENSURATELY INCREASED FOR GROUNDWATER ELEVATION ABOVE THE PIPE, IN ACCORDANCE WITH UNI-B-6 BY UNI-BELL PLASTIC PIPE ASSOCIATION.

METHOD:

- CLEAN AND WET THOROUGHLY THE INSIDE OF THE PIPE BEFORE TEST IS PERFORMED.
- INSERT TEST PLUGS IN ENDS OF PIPE TO BE TESTED.
- SLOWLY FILL THE PIPE WITH AIR TO A PRESSURE OF 4 PSIG.
- MAINTAIN PRESSURE BETWEEN 4 AND 3.5 PSIG FOR AT LEAST TWO MINUTES FOR TEMPERATURE STABILIZATION.
- CHECK ALL PLUGS FOR TIGHTNESS.
- WITH A PRESSURE OF APPROXIMATELY 4 PSIG IN PIPE, DISCONNECT AIR SUPPLY.
- ALLOW PRESSURE TO DECREASE TO 3.5 PSIG.
- DETERMINE ELAPSED TIME FOR PRESSURE DROP FROM 3.5 PSIG TO 2.5 PSIG.

THE LINE IS CONSIDERED ACCEPTABLE IF THE TIME FOR THE PRESSURE TO DECREASE FROM 3.5 PSIG TO 2.5 PSIG IS NOT LESS THAN THE AMOUNT DETERMINED BY THE FOLLOWING TABLE EXCEPT THAT REINFORCED CONCRETE PIPE SHALL BE HALF THIS DURATION.

PIPE DIAMETER (IN.)	MINIMUM TIME (MIN/SEC)	LENGTH FOR MINIMUM TIME (FT.)	TIME FOR LONGER LENGTH (SEC.)
4	3:40	397	0.380 L
6	5:40	389	0.854 L
8	7:34	298	1.520 L
10	9:26	239	2.374 L
12	11:20	194	3.418 L

WHERE L IS THE EXCESS TEST LENGTH BEYOND THE LENGTH FOR MINIMUM TIME.

IF THE LEAKAGE IN THE SECTION TESTED EXCEEDS THE SPECIFIED AMOUNT, THE CONTRACTOR SHALL MAKE THE NECESSARY REPAIRS OR REPLACEMENTS REQUIRED TO REDUCE THE LEAKAGE TO WITHIN THE SPECIFIED LIMITS AND THE TEST SHALL BE REPEATED UNTIL THE LEAKAGE REQUIREMENTS ARE MET.

THE CONTRACTOR MAY AT HIS OPTION, INFILTRATION/EXFILTRATION TEST ALL SEWER PIPE IN LIEU OF AIR TEST.


DEFLECTION TESTING SHALL BE PERFORMED IN ACCORDANCE WITH SECTION 33.85 OF THE "TEN STATES STANDARDS"

HYDRANT FLOW TEST RESULTS PER MCWA

FLOW TESTS WERE PERFORMED BY THE MCWA ON 3/7/24 WITH THE FOLLOWING RESULTS:
LOCATION: HARD ROAD IN FRONT OF SUBJECT PARCEL
STATIC PRESSURE: 73 PSI
OBSERVED Q: 1296 GPM
RESIDUAL PRESSURE: 66 PSI
Q AT 20 PSI: 3867 GPM

MAP REFERENCES:

- PLAN SET ENTITLED "SITE DEVELOPMENT PANS FOR TOWN OF WEBSTER 925 HARD ROAD." AS PREPARED BY APD ENGINEERING AND ARCHITECTURE AND DATED 4/23/2015
- PLAN SET ENTITLED "WEBSTER SQUARE HARD ROAD OUTPARCEL IMPROVEMENTS" AS PREPARED BY BERGMANN ASSOCIATES AND DATED FEBRUARY 2013.

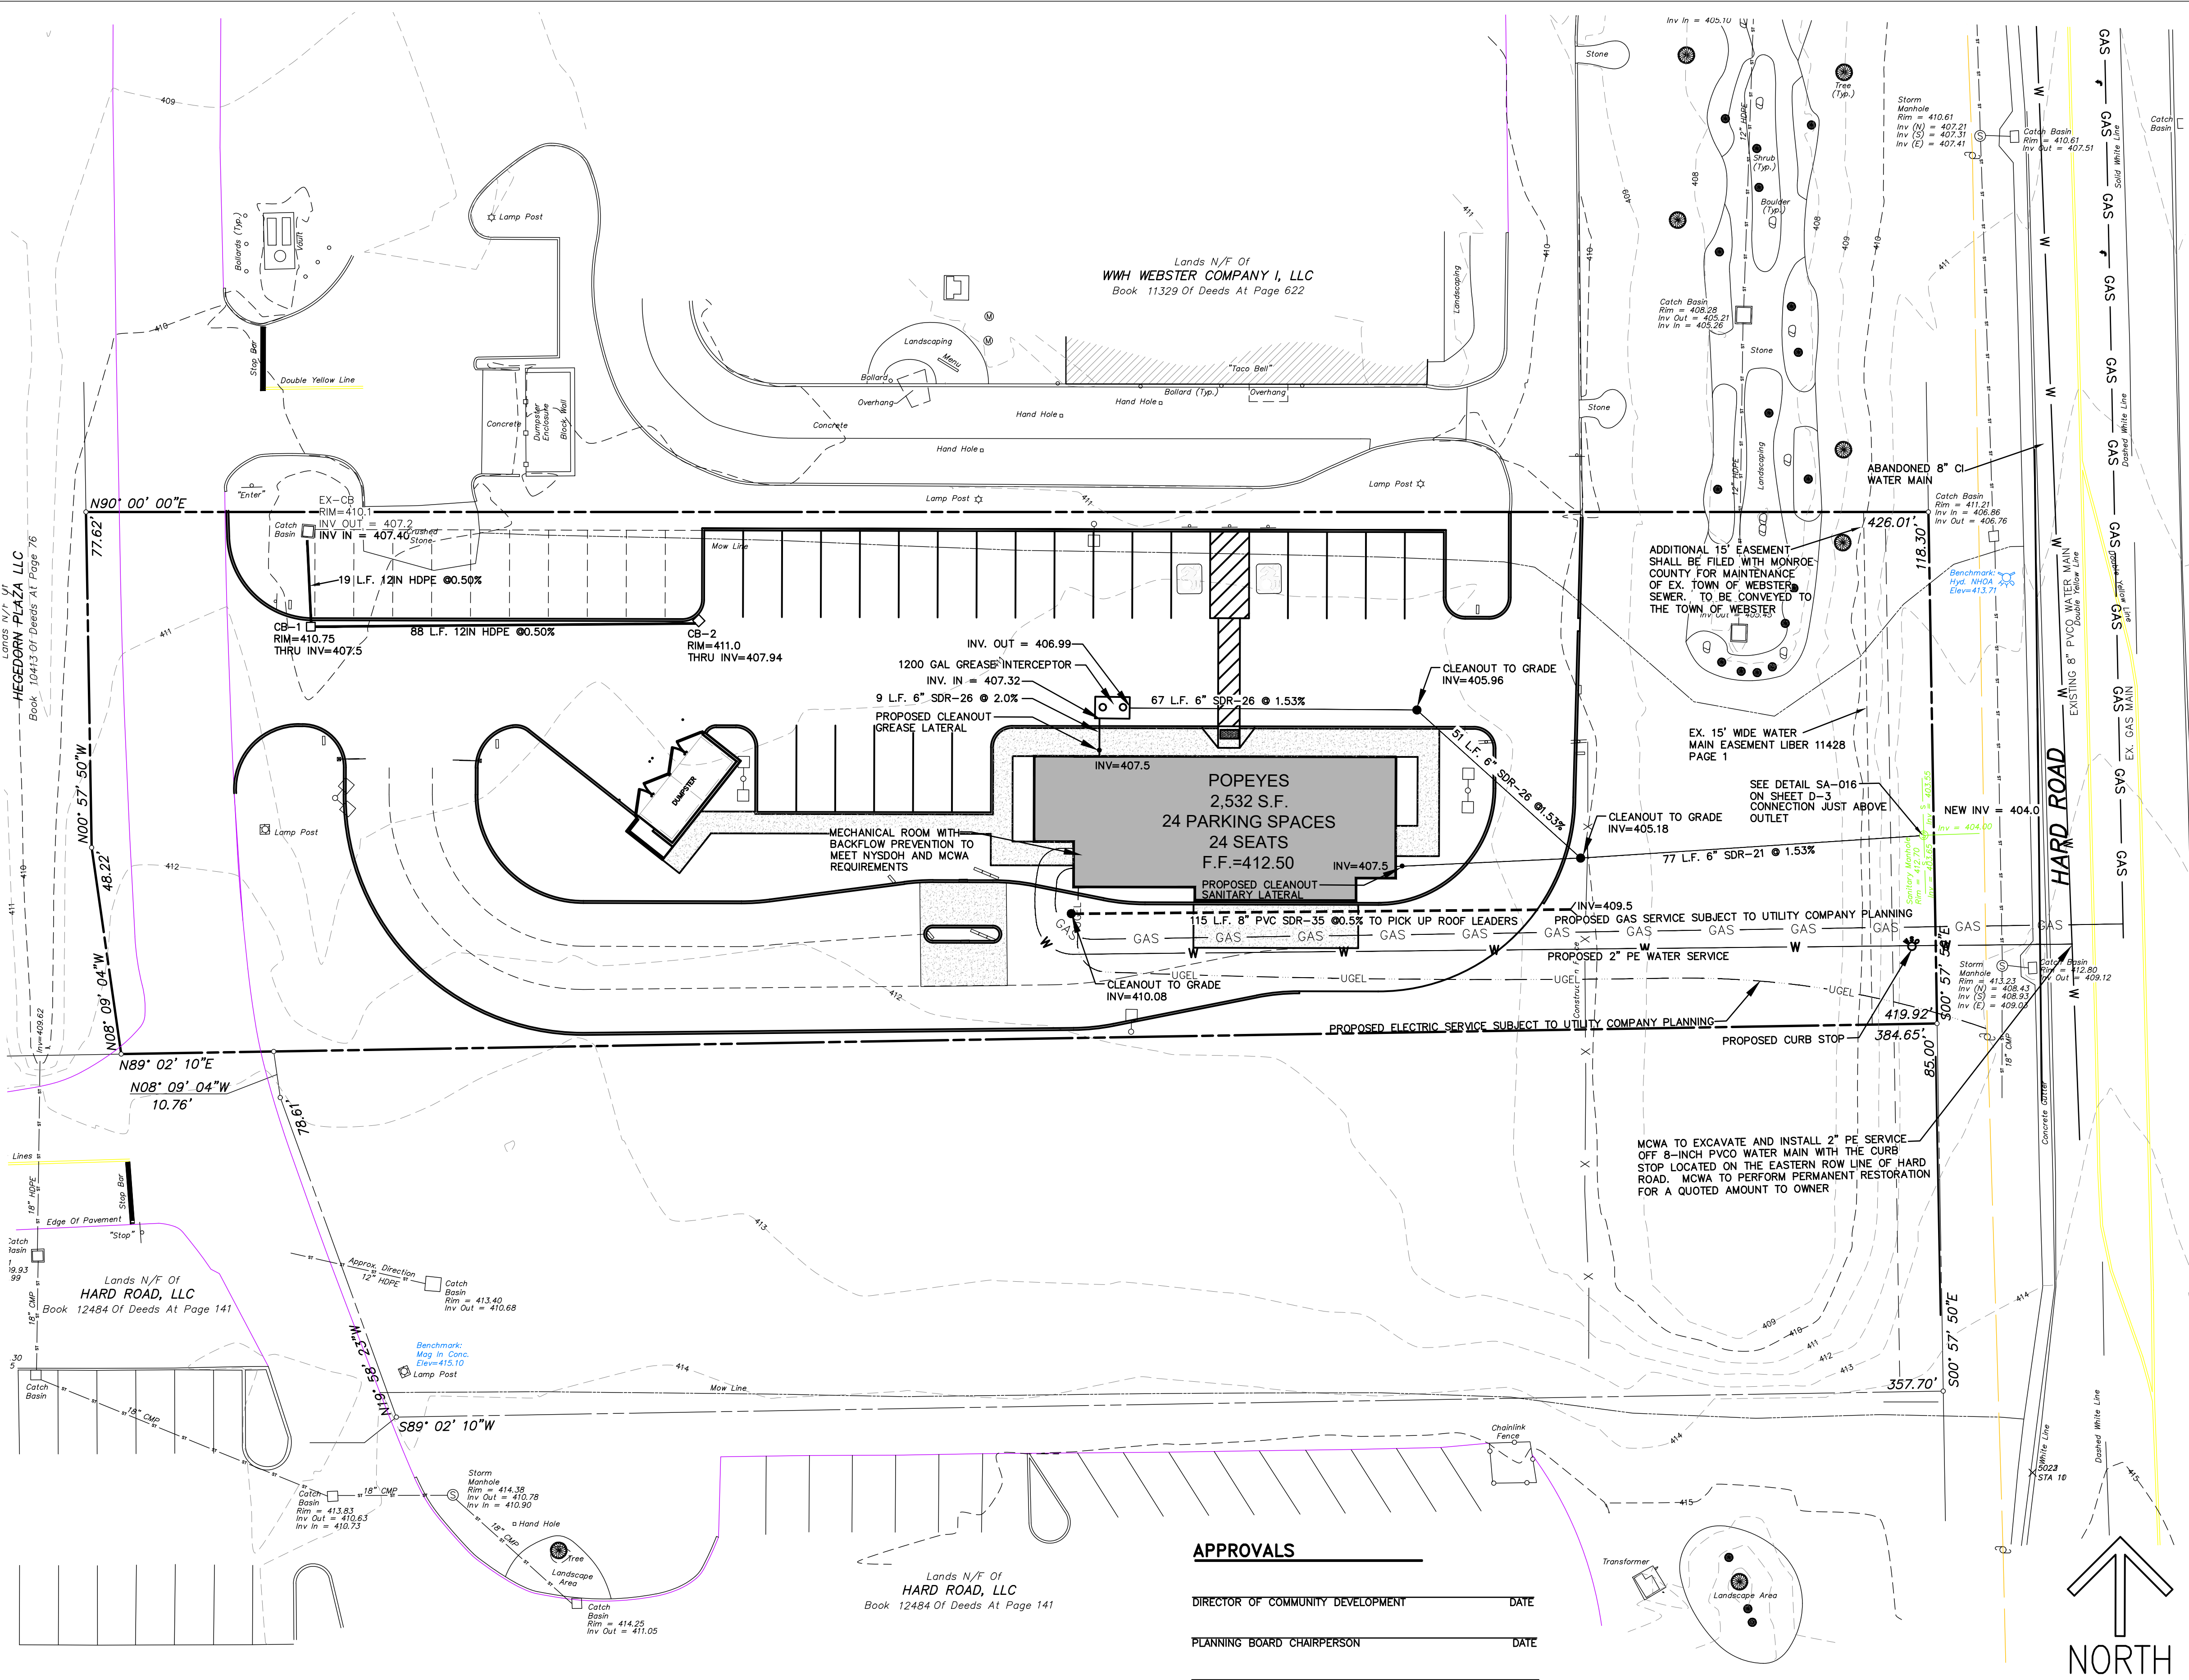

APPROVALS

DIRECTOR OF COMMUNITY DEVELOPMENT	DATE
PLANNING BOARD CHAIRPERSON	DATE
FIRE MARSHALL	DATE
TOWN OF WEBSTER SEWER DISTRICT	DATE
TOWN ENGINEER	DATE
TOWN OF WEBSTER HIGHWAY SUPERINTENDENT	DATE
TOWN OF WEBSTER ASSESSOR	DATE
MONROE COUNTY WATER AUTHORITY	DATE

UTILITY PLAN
LIBERTY RESTAURANTS
HARD ROAD

COUNTY OF MONROE
DRAWN BY: BLS
CADD FILE:

STATE OF NEW YORK
TOWN OF WEBSTER
CHECKED BY:
JOB NO.

SCALE: 1" = 20'

SHEET C-3

BRETT L. STEENBURGH, P.E. PLLC
2832 Rosendale Road
Niskayuna, NY 12309
(518) 365-0875
bsteenburgpe@gmail.com

ENGINEERING THAT TRANSFORMS
IMAGINATION INTO REALITY

COUNTY OF MONROE
DATE: OCTOBER 17, 2023

Call 811
before you dig

Scaling off these drawings shall be done only for review and approval purposes. Contractors shall not scale drawings for layout and construction.

Unauthorised alterations or additions to these drawings shall be the responsibility of the person making the alterations. The person making the alterations shall be responsible for obtaining the necessary permits and approvals from the appropriate authorities.

Copyright 2021 Brett L. Steenburg, P.E. PLLC
Sub. 2 of the NYS Education Law
No part of this publication may be reproduced without the express written consent of Brett L. Steenburg, P.E. PLLC

STATE OF NEW YORK
BRETT L. STEENBURGH, P.E.
N.Y.S. ID. NO. 072408

NO.	DATE:	REVISIONS	BY:
1	12/29/23	REVISED AS PER THE COMMENTS	
2	2/23/24	REVISED AS PER THE COMMENTS	
3	4/17/24	REVISED AS PER THE COMMENTS	
4	4/17/24	REVISED AS PER THE COMMENTS	

SITE PREPARATION:
 1. SEEDBED PREPARATION -- SCARIFY IF COMPACTED. REMOVE DEBRIS
 AND OBSTACLES SUCH AS ROCKS AND STUMPS.
 2. SOIL AMENDMENTS:
 A. LIME TO A PH OF 6.0
 B. FERTILIZE WITH 600LBS OF 5-10-10 OR EQUIV. PER ACRE
 (14LBS/1000 S.F.)
 3. POST SEEDING FERTILIZATION AND WATERING IS THE RESPONSIBILITY OF
 THE CONTRACTOR UNTIL ACCEPTED BY THE OWNER AS DESCRIBED IN THE
 PROJECT SPECIFICATIONS



MAP REFERENCES:

1. PLAN SET ENTITLED "SITE DEVELOPMENT PANS FOR TOWN OF WEBSTER 925 HARD ROAD," AS PREPARED BY APD ENGINEERING AND ARCHITECTURE AND DATED 4/23/2015
2. PLAN SET ENTITLED "WEBSTER SQUARE HAD ROAD OUTPARCEL IMPROVEMENTS" AS PREPARED BY BERGMANN ASSOCIATES AND DATED FEBRUARY 2013.



DIRECTOR OF COMMUNITY DEVELOPMENT	DATE
PLANNING BOARD CHAIRPERSON	DATE
FIRE MARSHALL	DATE
TOWN OF WEBSTER SEWER DISTRICT	DATE
TOWN ENGINEER	DATE
TOWN OF WEBSTER HIGHWAY SUPERINTENDENT	DATE
TOWN OF WEBSTER ASSESSOR	DATE
MONROE COUNTY WATER AUTHORITY	DATE


LANDSCAPING PLAN		BRETT L. STEENBURGH, P.E. PLLC	
LIBERTY RESTAURANTS		2832 Rosendale Road	
HARD ROAD		Niskayuna, NY 12309	
TOWN OF WEBSTER		(518) 365-0675	
		bsteenburgpe@gmail.com	
COUNTY OF MONROE	STATE OF NEW YORK	ENGINEERING THAT TRANSFORMS IMAGINATION INTO REALITY	
DRAWN BY: BLS	CHECKED BY:	SCALE: 1" = 20'	SHEET C-4
CADD FILE:	JOB NO.		
DATE: OCTOBER 17, 2023			

LEGEND

- PROPERTY LINE
-210- PROPOSED CONTOUR
-210- EXISTING CONTOUR
x214.25 PROPOSED SPOT ELEVATION
→ PROPOSED DRAINAGE FLOW ARROW

EROSION AND SEDIMENT CONTROL NOTES:

1. A PRE-CONSTRUCTION MEETING MUST BE HELD WITH THE SITE CONTRACTOR, SWPPP INSPECTOR, PROPERTY OWNER AND THE TOWN PRIOR TO ISSUANCE OF A BUILDING PERMIT.
2. ESTABLISH A PERMANENT TRAFFIC CORRIDOR FOR ALL TRAFFIC DURING CONSTRUCTION. A STONE STABILIZED CONSTRUCTION ENTRANCE MUST BE INSTALLED AND INSPECTED AND APPROVED BY THE STORMWATER OFFICE PRIOR TO ISSUANCE OF A BUILDING PERMIT. TRAFFIC SHALL NOT CROSS OR OPERATE UNNECESSARILY WITHIN WATERWAYS OR DRAINAGE DITCHES.
3. IF REQUESTED BY THE TOWN OR ENGINEER, ADDITIONAL SILT FENCE MUST BE INSTALLED A MINIMUM OF 6 INCHES INTO THE GROUND SURFACE.
4. ANY SOILS TRACKED INTO PUBLIC ROADS MUST BE SWEEPED UP IMMEDIATELY. CONCRETE POURING MAY NOT TAKE PLACE UNTIL A CONCRETE WASHOUT AREA IS INSTALLED.
5. ANY PUMPING OF STORMWATER ON SITE MUST BE DISCHARGED THROUGH A FILTER AND/OR STONE.
6. A FINAL GRADING INSPECTION IS REQUIRED WITH THE STORMWATER OFFICE PRIOR TO ISSUANCE OF A CERTIFICATE OF OCCUPANCY. ALL EXPOSED SOILS MUST BE STABILIZED AND APPROVED. IF THE C.O. IS NEEDED DURING NON GROWING MONTHS, THE OWNER MUST PROVIDE A GRADING ESCROW TO THE STORMWATER OFFICE FOR THE OUTSTANDING WORK TO BE COMPLETED DURING THE GROWING MONTHS.
7. TOTAL AREA OF DISTURBANCE IS APPROXIMATELY 45,500 S.F.
8. ALL EROSION AND CONTROL MEASURES SHALL BE IMPLEMENTED PRIOR TO SOIL DISTURBANCE.

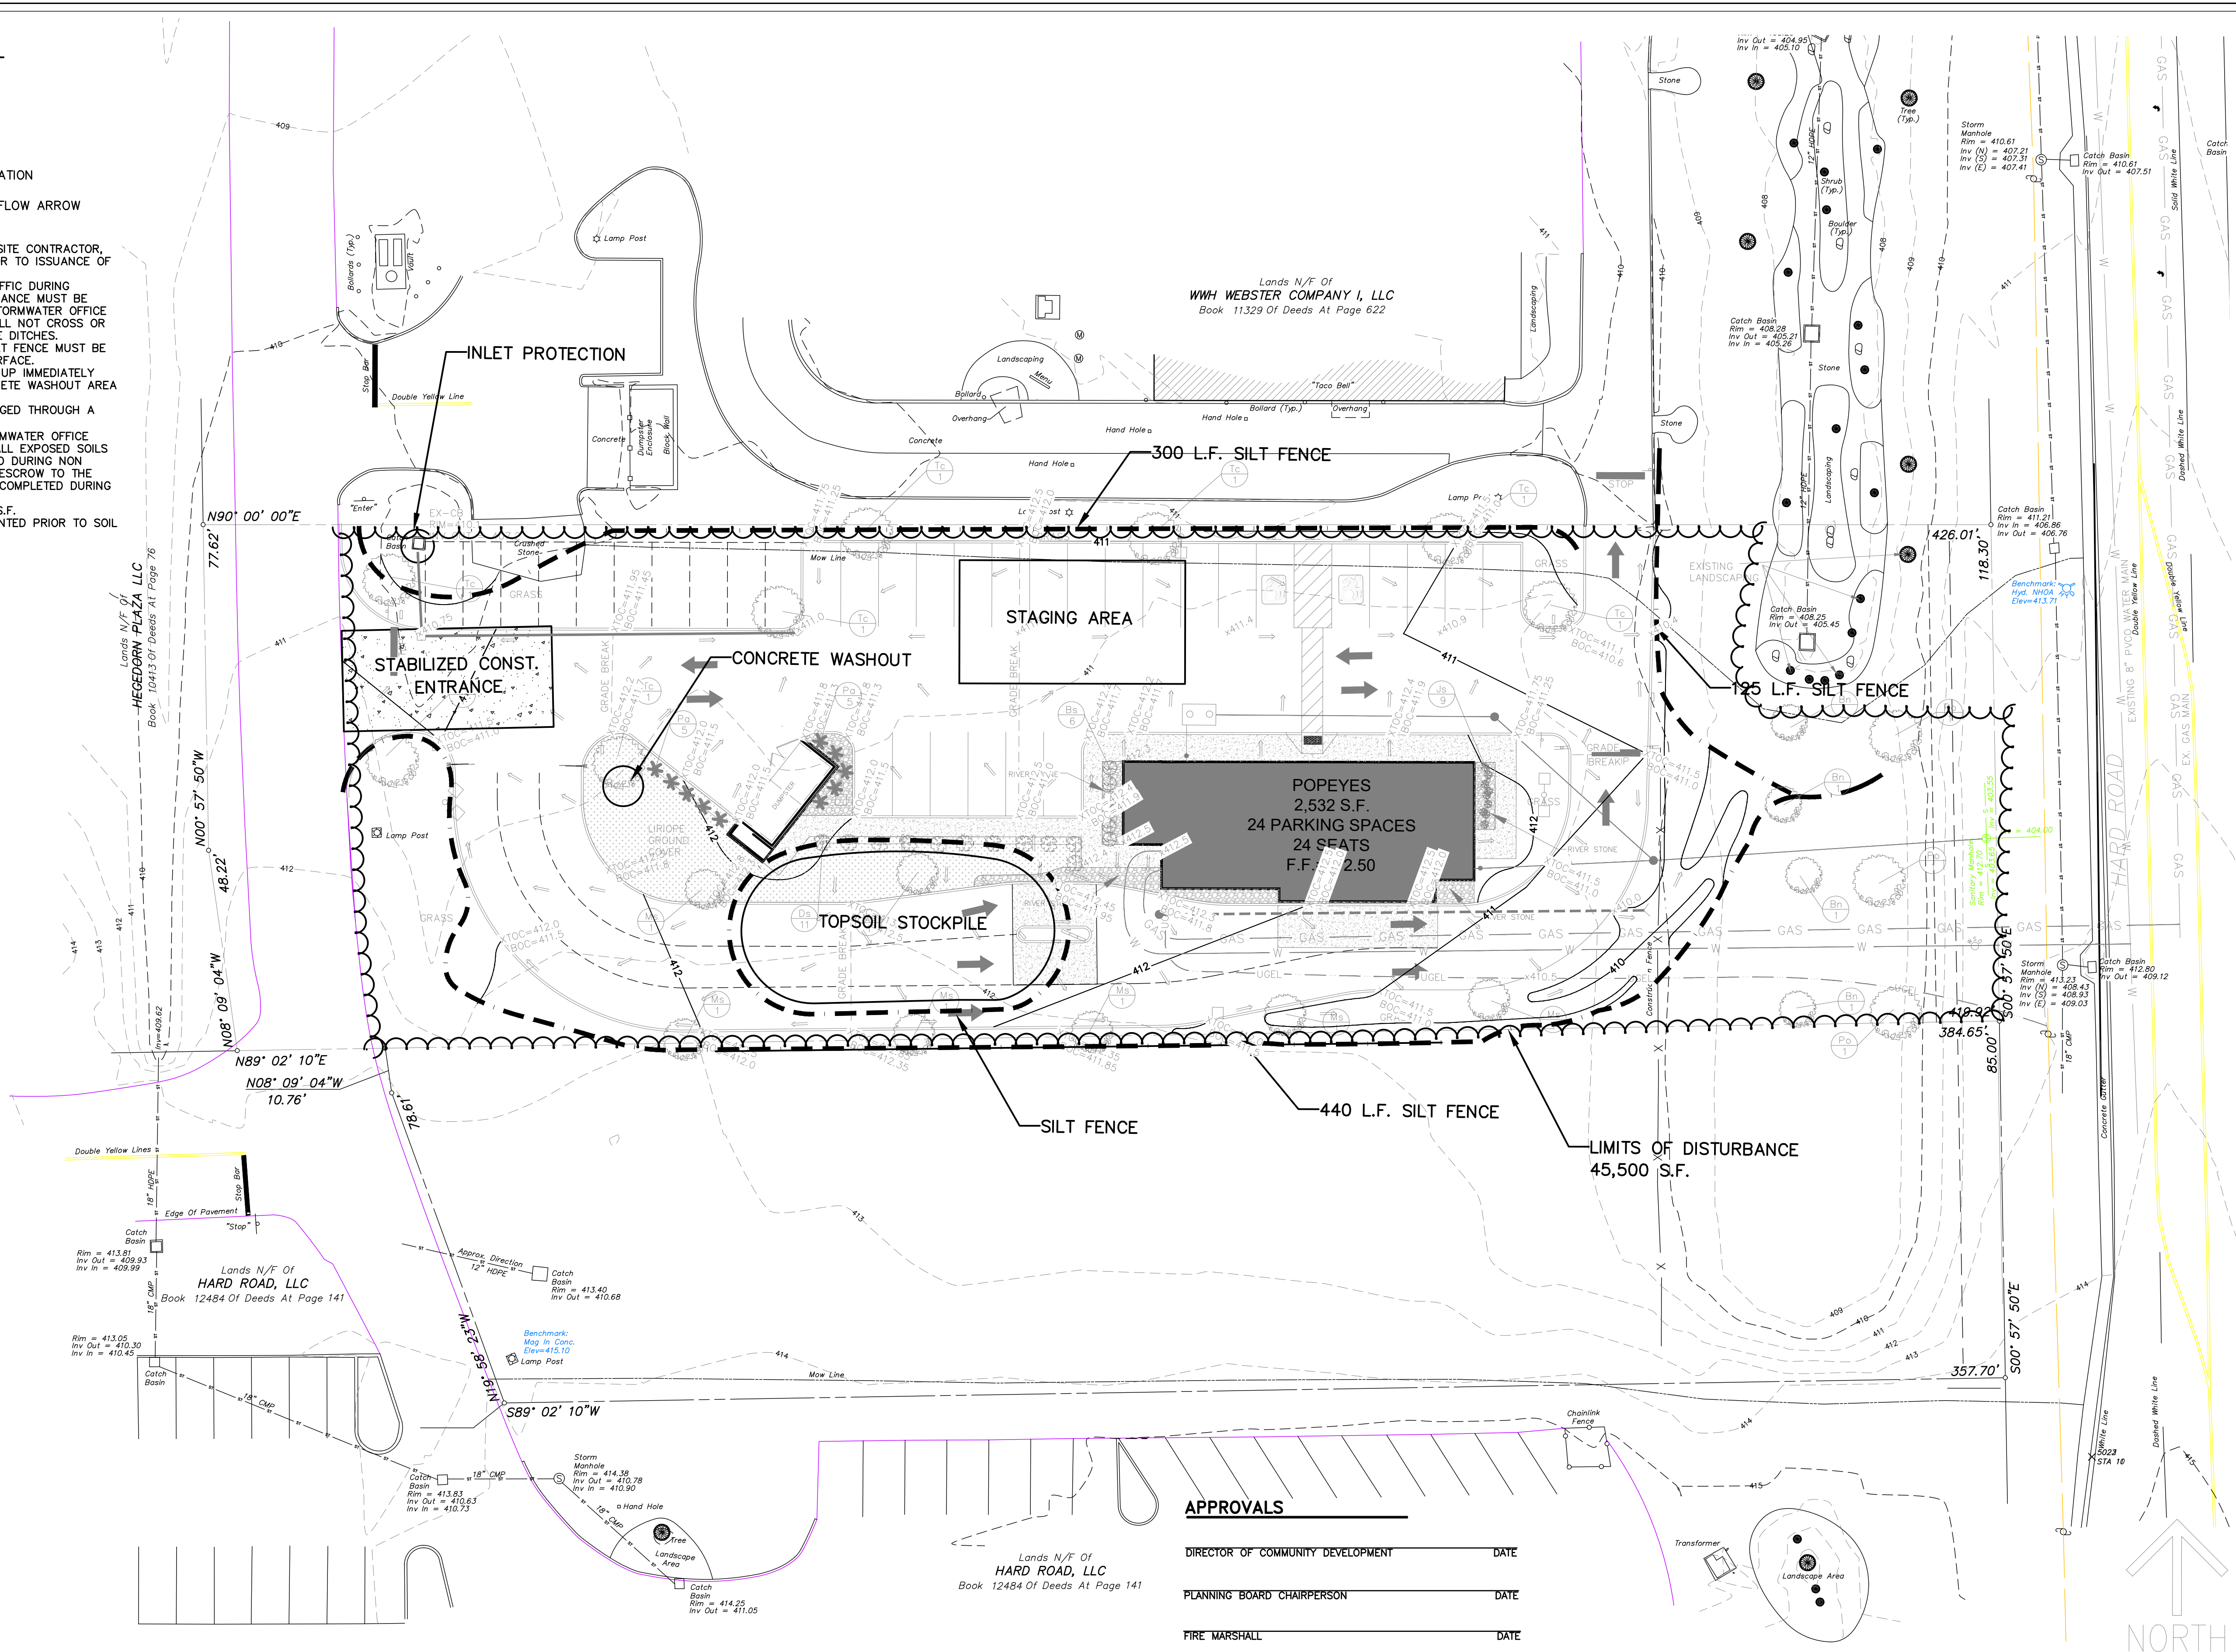

APPROVALS

DIRECTOR OF COMMUNITY DEVELOPMENT _____ DATE _____
PLANNING BOARD CHAIRPERSON _____ DATE _____
FIRE MARSHALL _____ DATE _____
TOWN OF WEBSTER SEWER DISTRICT _____ DATE _____
TOWN ENGINEER _____ DATE _____
TOWN OF WEBSTER HIGHWAY SUPERINTENDENT _____ DATE _____
TOWN OF WEBSTER ASSESSOR _____ DATE _____
MONROE COUNTY WATER AUTHORITY _____ DATE _____

- MAP REFERENCES:
1. PLAN SET ENTITLED "SITE DEVELOPMENT PANS FOR TOWN OF WEBSTER 925 HARD ROAD," AS PREPARED BY APD ENGINEERING AND ARCHITECTURE AND DATED 4/23/2015
 2. PLAN SET ENTITLED "WEBSTER SQUARE HARD ROAD OUTPARCEL IMPROVEMENTS" AS PREPARED BY BERGMANN ASSOCIATES AND DATED FEBRUARY 2013.

BRETT L. STEENBURGH, P.E. PLLC

2832 Rosendale Road
Niskayuna, NY 12309
(518) 365-0875
bsteenburgpe@gmail.com

**ENGINEERING THAT TRANSFORMS
IMAGINATION INTO REALITY**

E & SC PLAN

LIBERTY RESTAURANTS
HARD ROAD

TOWN OF WEBSTER

COUNTY OF MONROE
DRAWN BY: BLS
CADD FILE:
DATE: OCTOBER 17, 2023

STATE OF NEW YORK
CHECKED BY:
JOB NO.

SCALE: 1" = 20'

SHEET C-6

Scaling of these drawings shall be done only for review and approval purposes. Contractors shall be responsible for providing electronic data only for layout and construction.

Unauthorized alterations or additions to these drawings are prohibited. The user of these drawings shall be responsible for obtaining the necessary permits and approvals for the project. The user of these drawings shall be responsible for obtaining the necessary permits and approvals for the project.

Copyright 2021 Brett L. Steenburg, P.E. PLLC
Sub 2 of the NYS Education Law
No part of this publication may be reproduced without the express written consent of Brett L. Steenburg, P.E. PLLC







BRETT L. STEENBURGH, P.E.
N.Y.S. Lic. No. 072408

Call 811

before you dig

Safe. New York.

NO.	DATE	REVISIONS
1	12/19/23	REVISED AS PER THE COMMENTS
2	12/19/23	REVISED AS PER THE COMMENTS
3	12/19/23	REVISED AS PER THE COMMENTS
4	4/17/24	ADDED IMPORTANT DATA

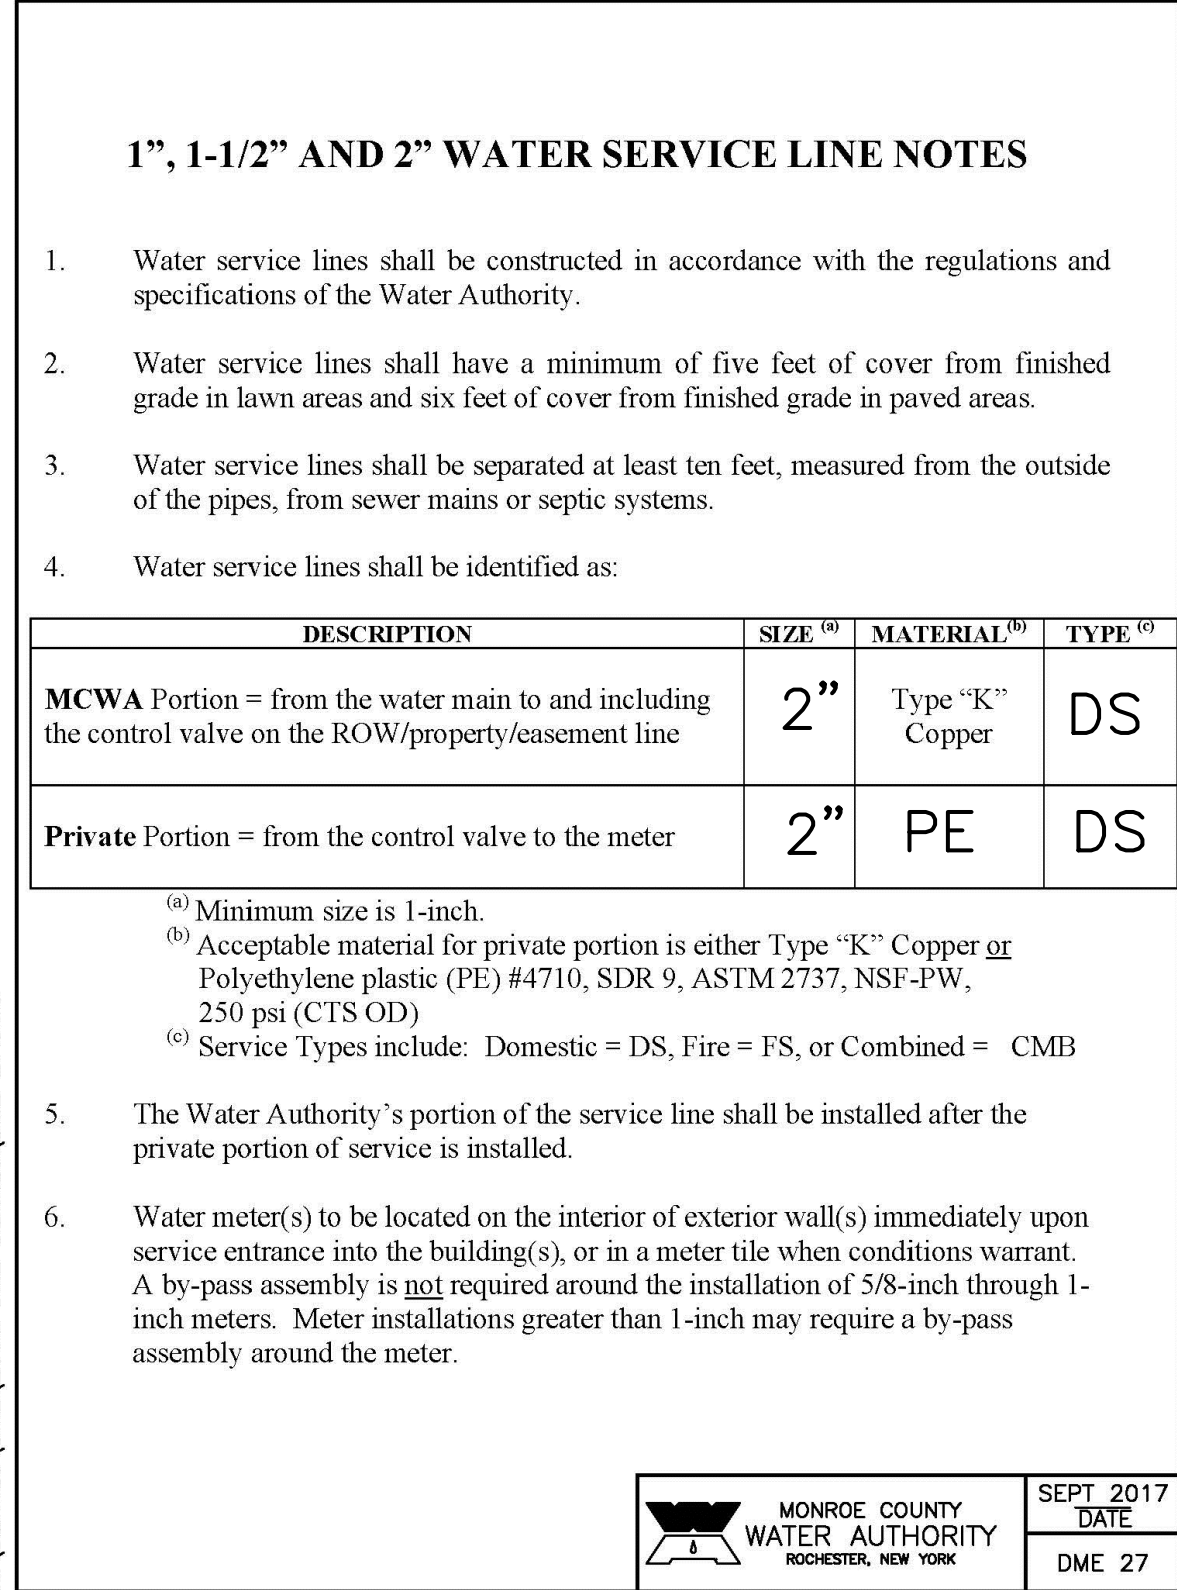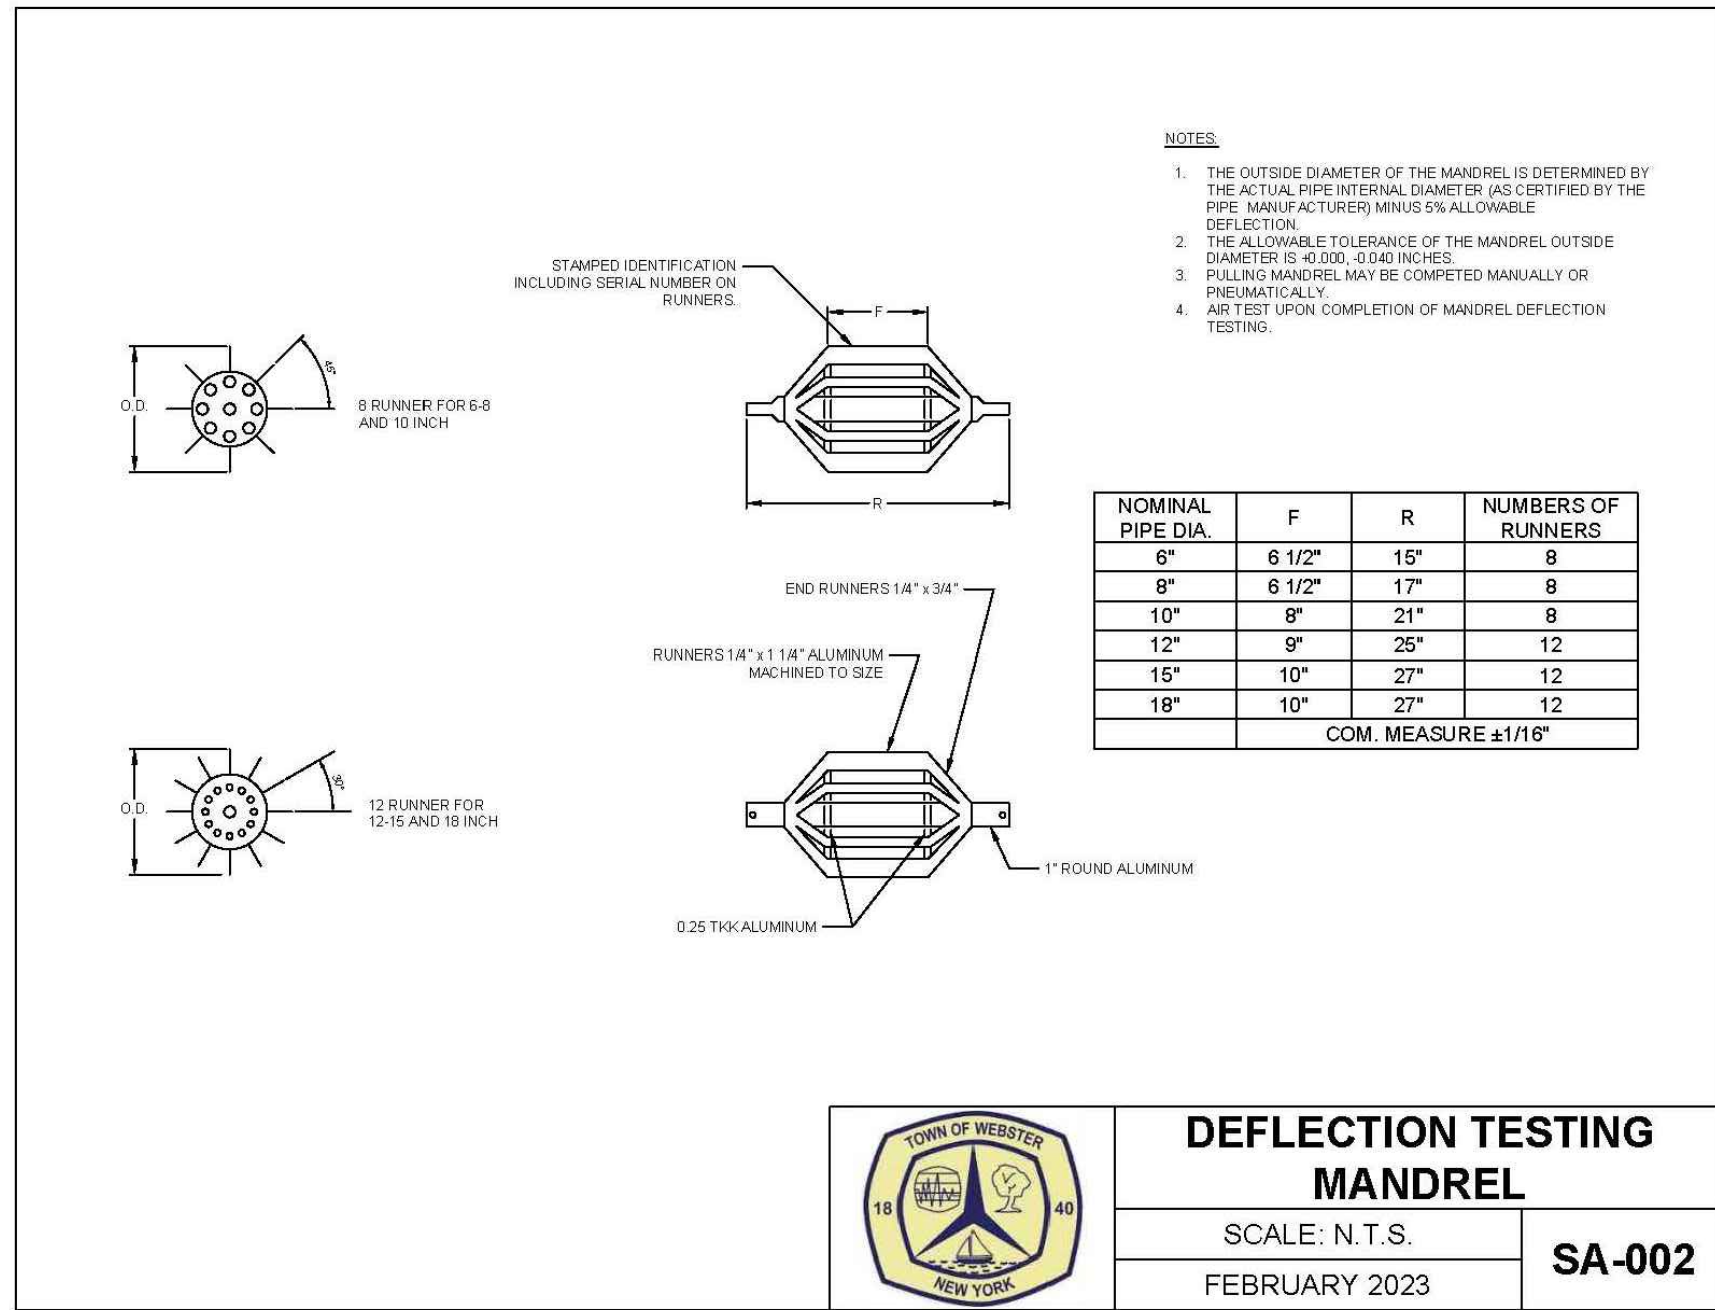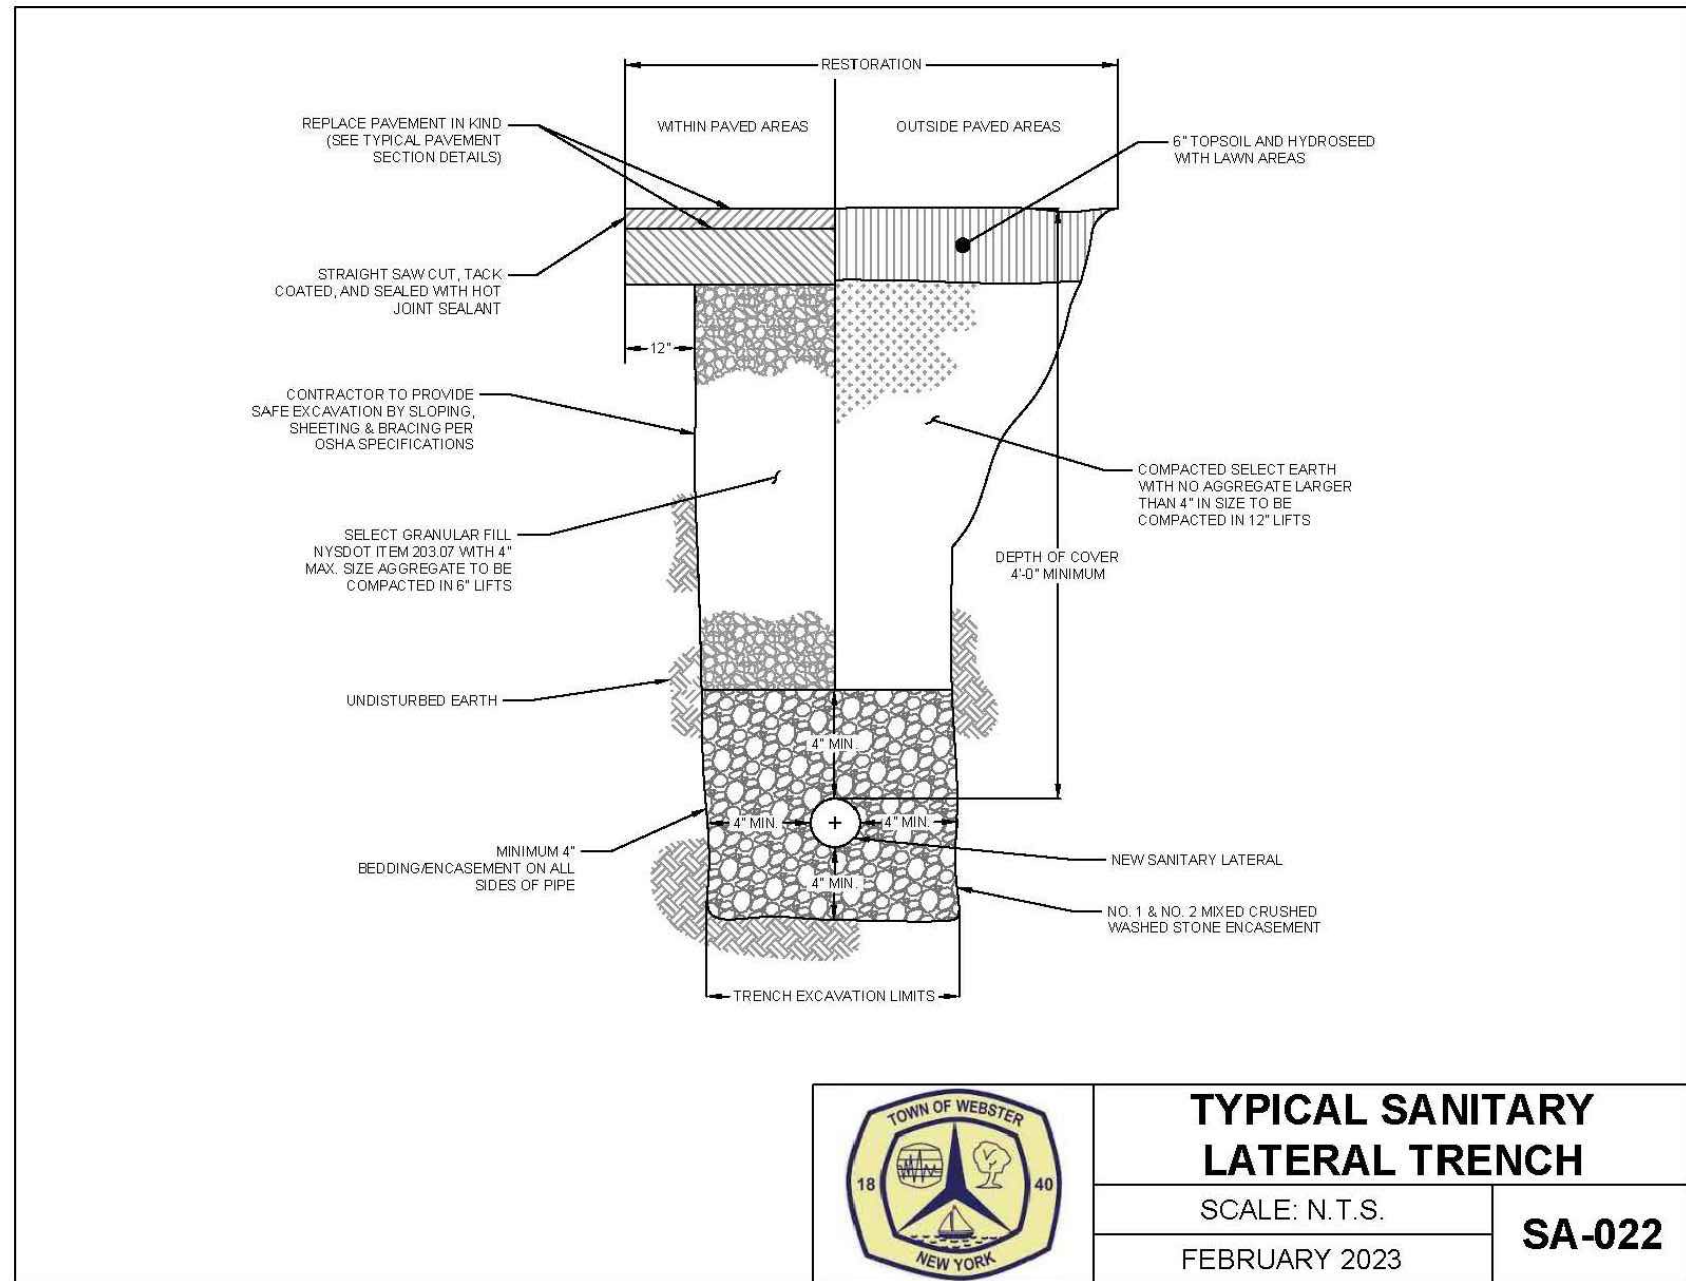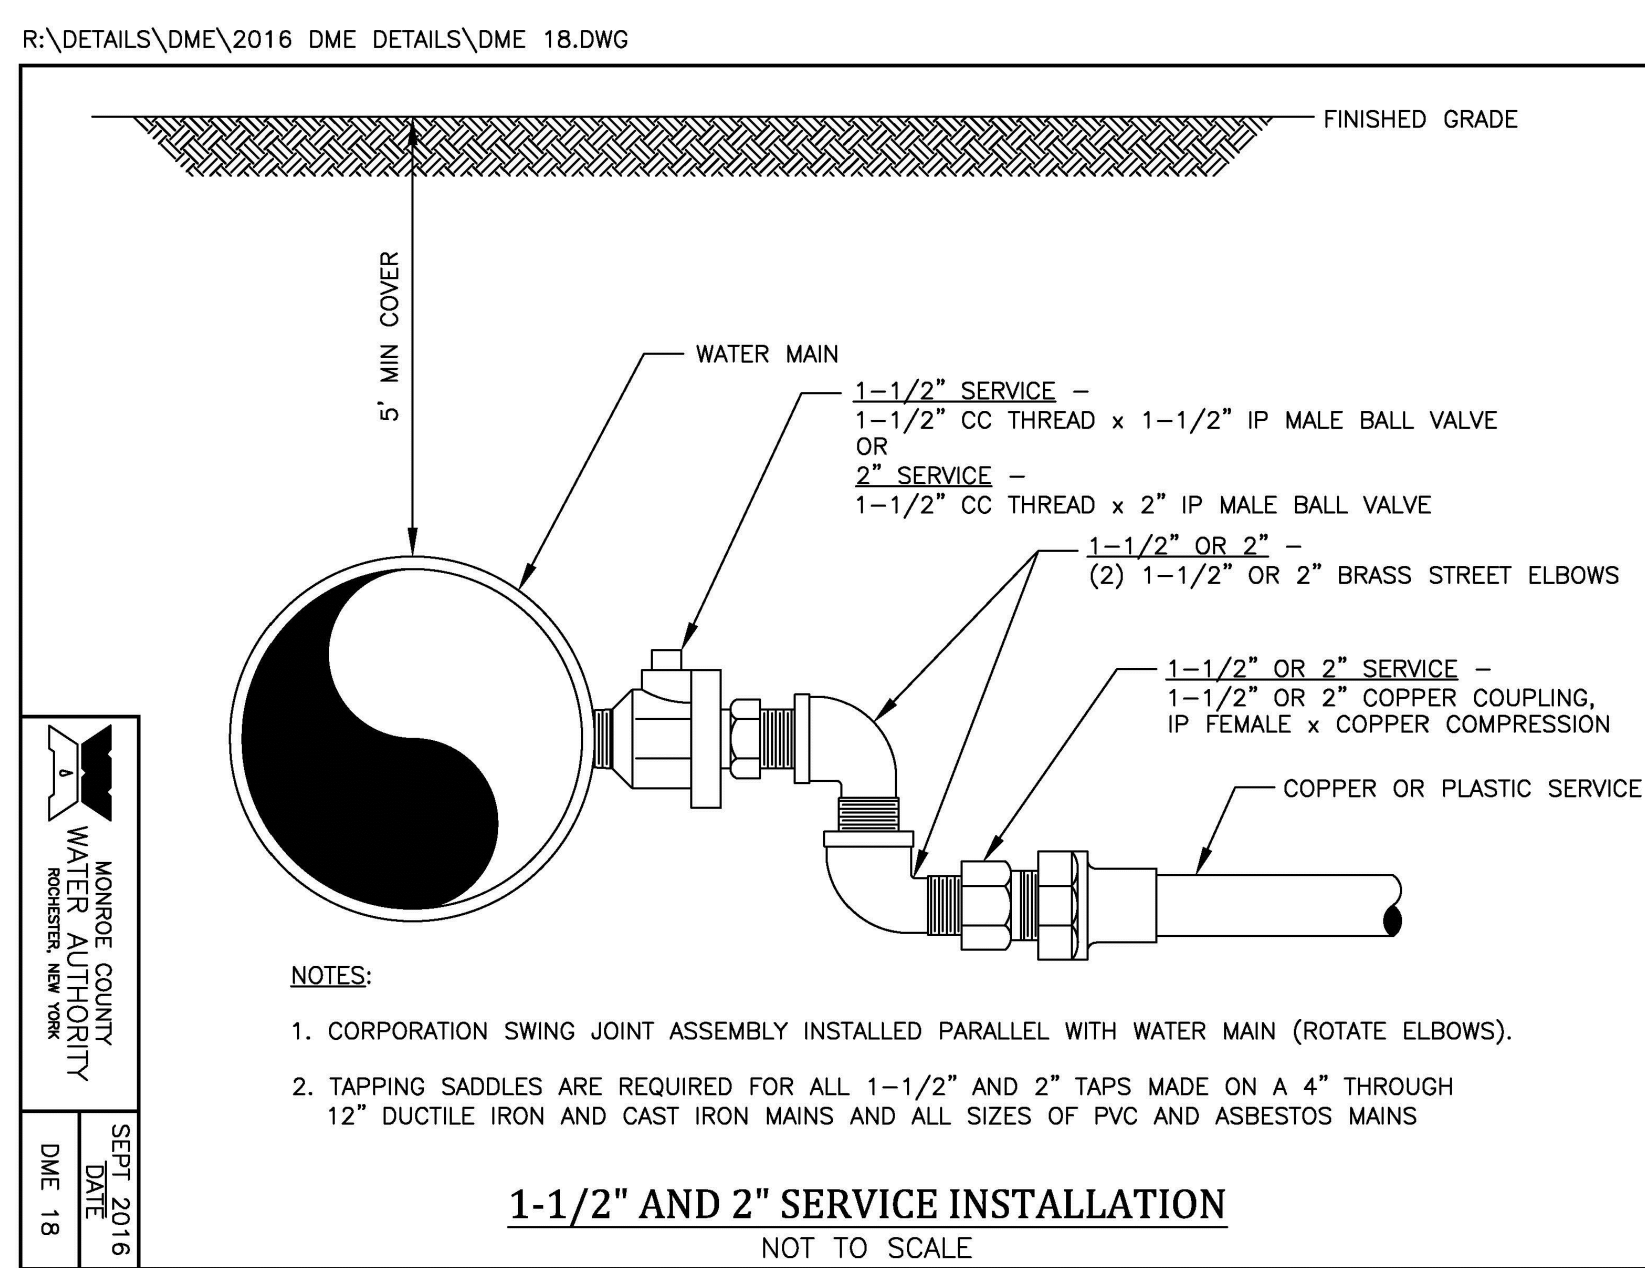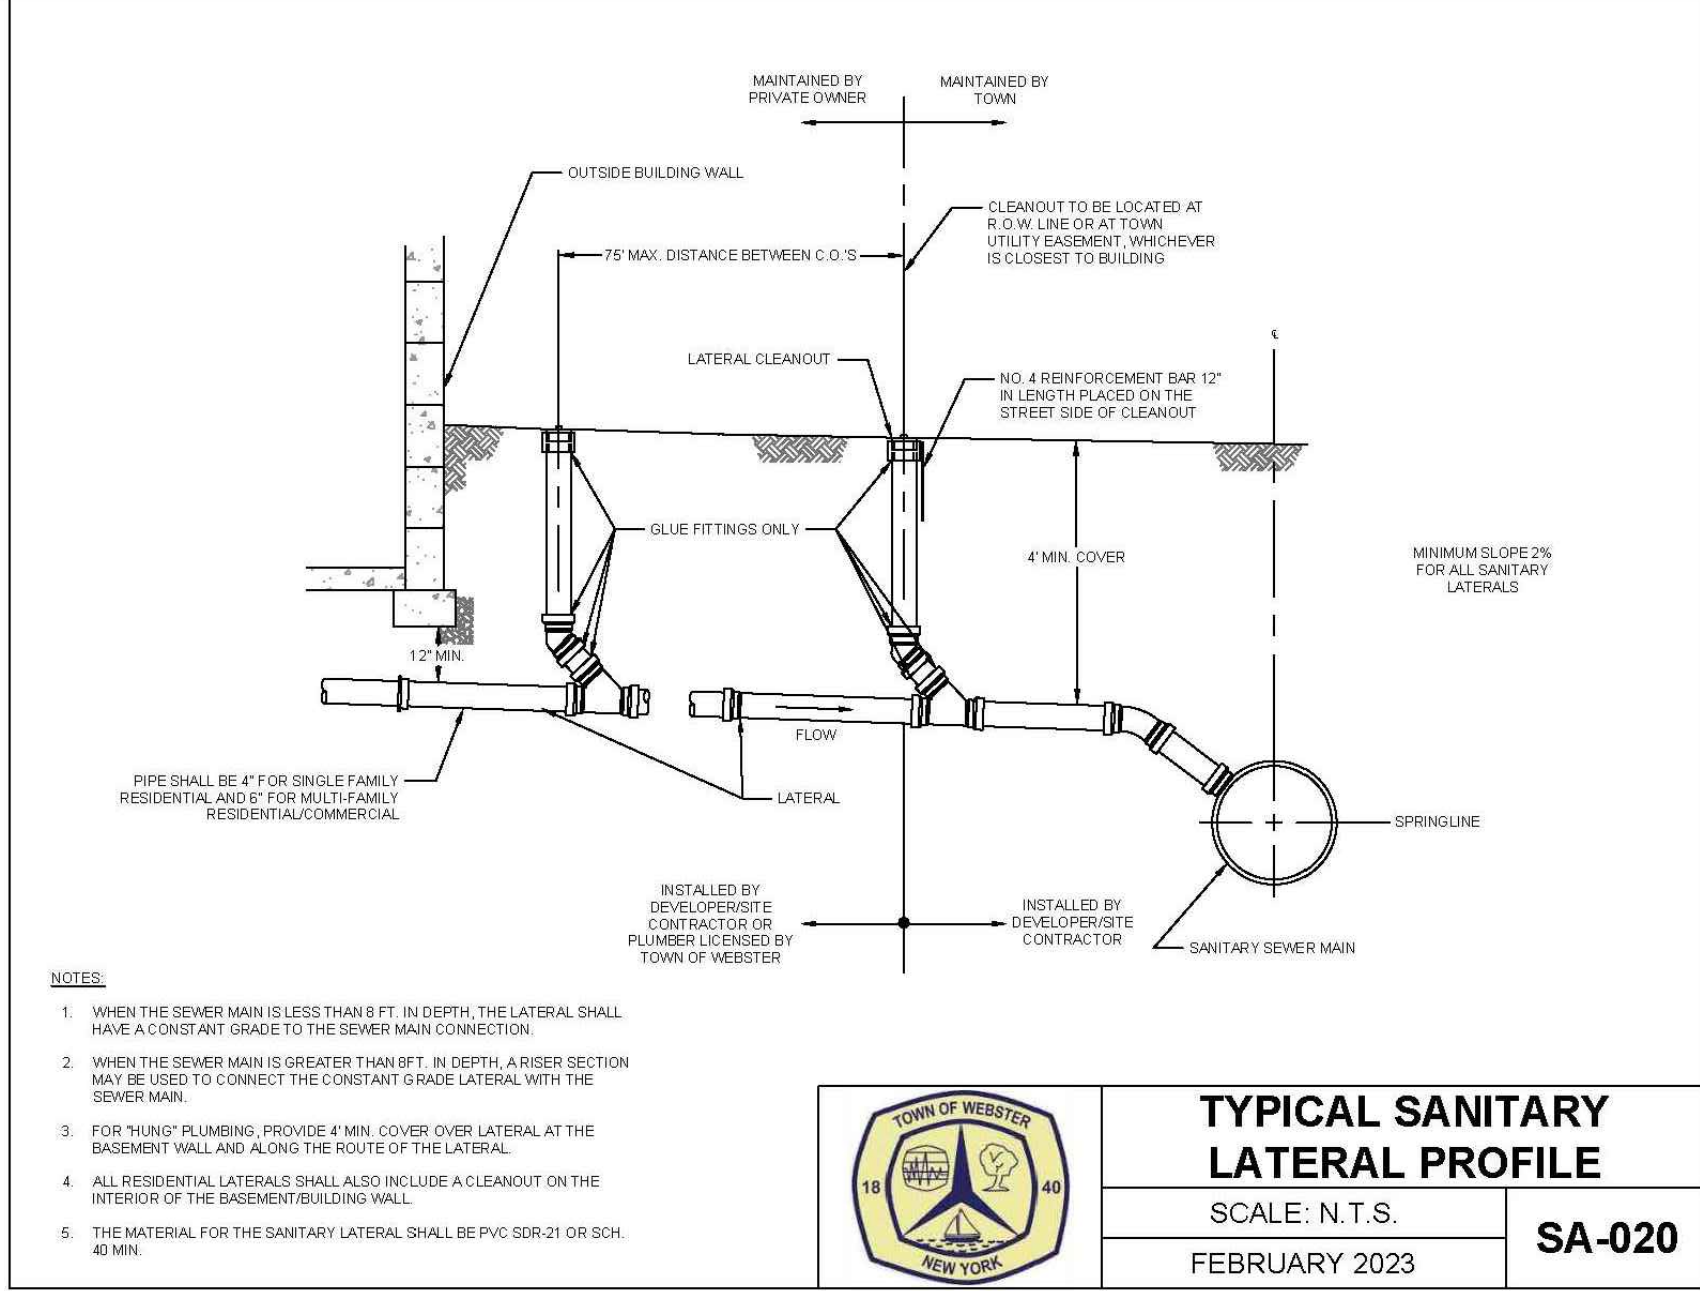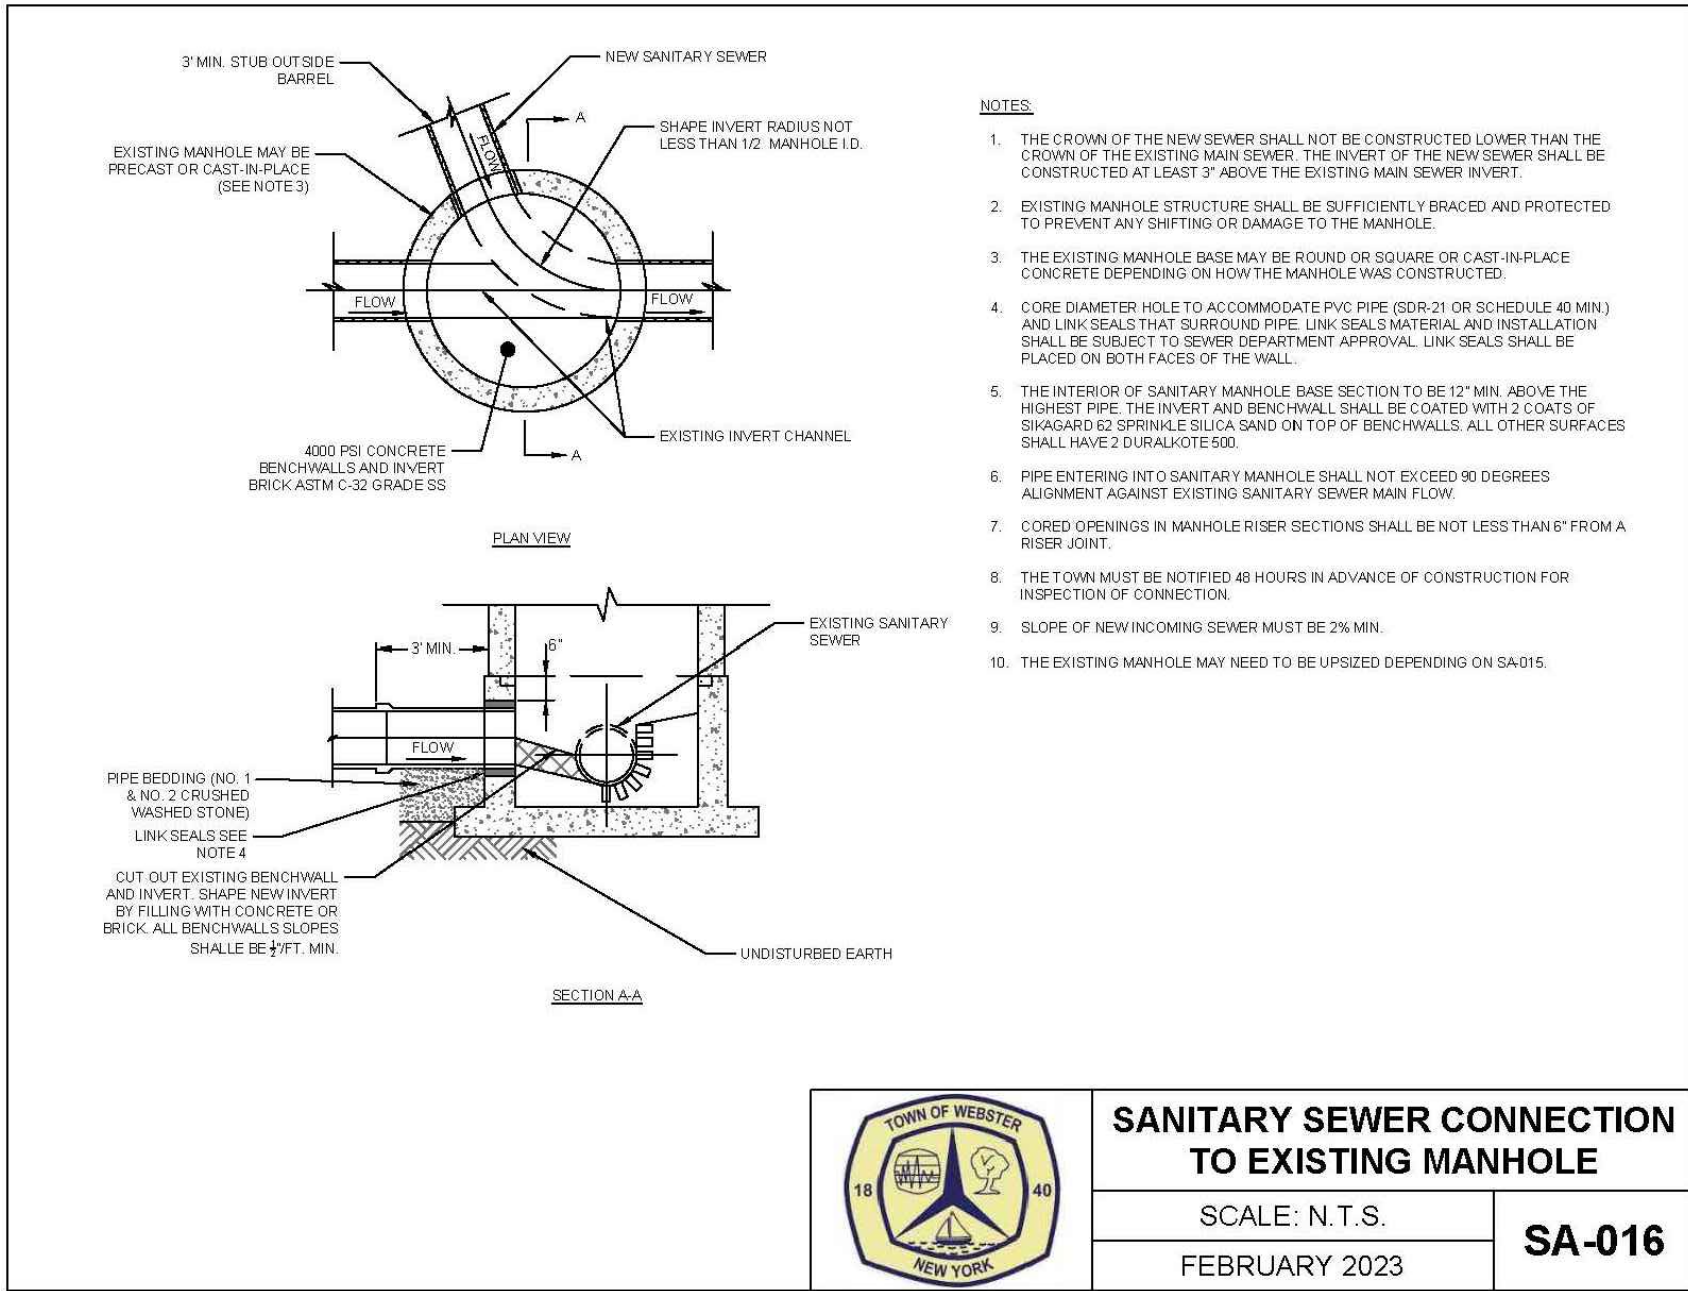

APPROVALS

DIRECTOR OF COMMUNITY DEVELOPMENT _____ DATE _____

PLANNING BOARD CHAIRPERSON _____ DATE _____

FIRE MARSHALL _____ DATE _____

TOWN OF WEBSTER SEWER DISTRICT _____ DATE _____

TOWN ENGINEER _____ DATE _____

TOWN OF WEBSTER HIGHWAY SUPERINTENDENT _____ DATE _____

TOWN OF WEBSTER ASSESSOR _____ DATE _____

MONROE COUNTY WATER AUTHORITY _____ DATE _____

DETAILS

LIBERTY RESTAURANTS

HARD ROAD

TOWN OF WEBSTER

COUNTY OF MONROE

CHECKED BY: _____

SCALE: AS NOTED

SHEET D-3

DATE: OCTOBER 17, 2023

BRETT L. STEENBURGH, P.E. PLLC

2832 Rosendale Road
Niskayuna, NY 12309
(518) 365-0675
bsteenburgpe@gmail.com

ENGINEERING THAT TRANSFORMS
IMAGINATION INTO REALITY

STATUTORY SEAL OF NEW YORK
BRETT L. STEENBURGH, P.E.
N.Y.S. ID. NO. 072468

Scaling off these drawings shall be done only for review and approval purposes. Contractors are not to scale drawings for layout and construction.

Unauthorized alterations or additions to these drawings are prohibited. Any such alterations or additions shall be the responsibility of the person making them. Copyright 2021, Brett L. Steenburgh, P.E. PLLC. All rights reserved. No part of this publication may be reproduced without the express written consent of Brett L. Steenburgh, P.E., PLLC.

NO. DATE: _____

REVISIONS

BY: _____

NO.	DATE	REVISIONS
4	4/17/24	ADDED HYDROSEED DATA
3	2/23/24	REVISED AS PER THE COMMENTS
2	1/29/23	REVISED AS PER THE COMMENTS
1		

APPROVALS

Calculation Summary; 1.00 LLF


Fixture Mounting Height: 20' AFG (18' Pole + 2.0' Base)

Pole Schedule
(5) CL-SSP-4011-18-OT-BZ (18' x 4" x 11ga; STEEL SQUARE POLE, Tenon)

Additional Equipment:

- (7) OSQ-ML-B-AA-BZ (Adjustable Arm Mount)
- (1) PB-1A4 (Single Head Tenon)
- (3) PB-2A4 (Twin Head Tenon)

*** CUSTOMER TO VERIFY ORDERING INFORMATION AND CATALOGUE NUMBER PRIOR TO PLACING ORDER ***

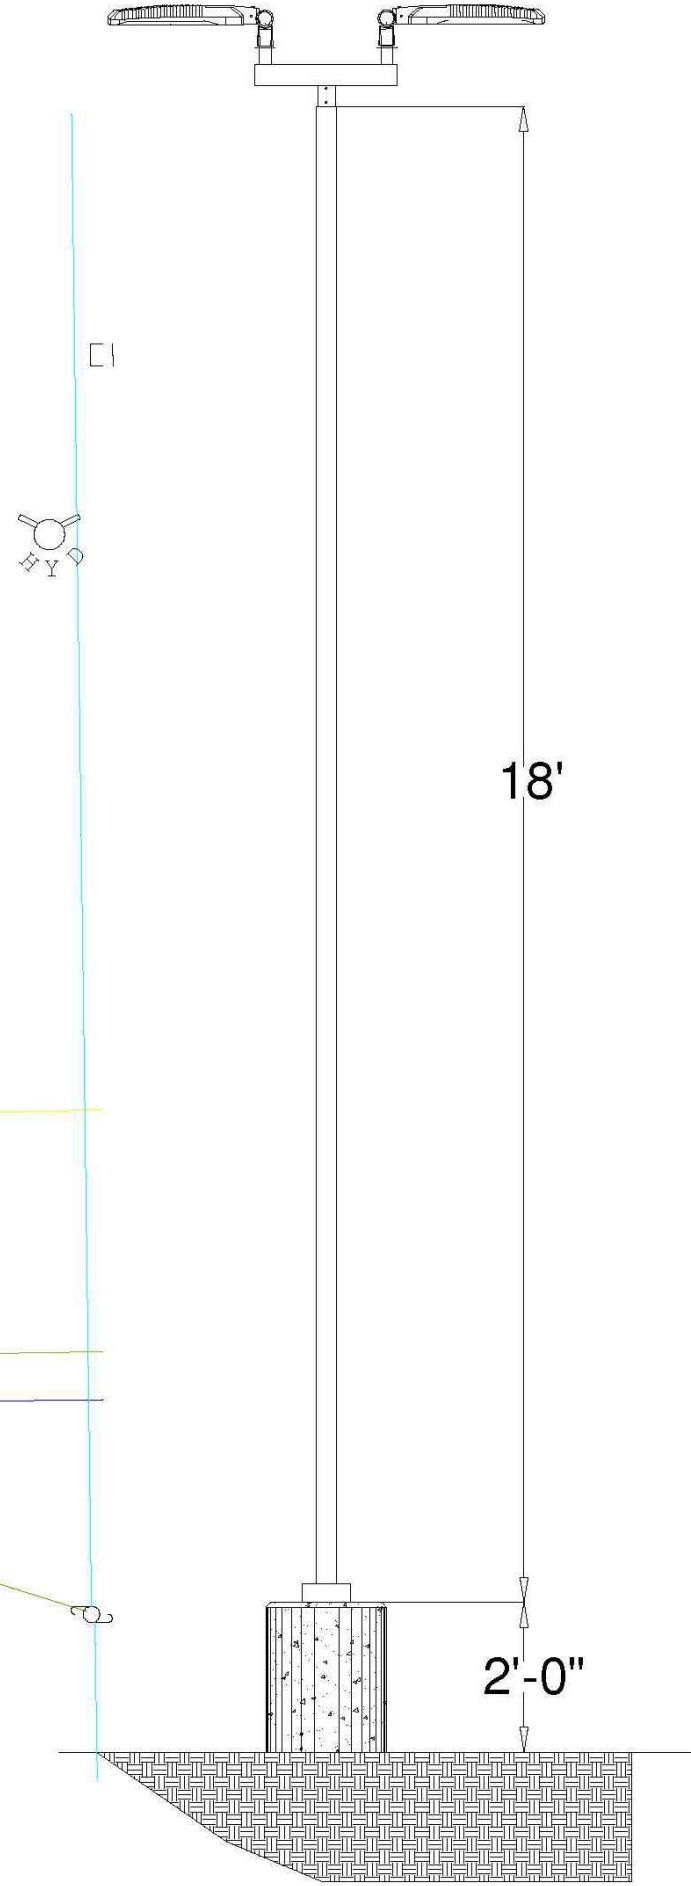

illumination results shown on this lighting design are based on project parameters provided to Cree Lighting used in conjunction with luminaires test procedures conducted under laboratory conditions. Actual project conditions differing from these design parameters may affect field results. The customer is responsible for verifying dimensional accuracy along with compliance with any applicable electrical, lighting or energy code.

Project Name: Popeyes - 10518 Bennett Road Dunkirk, NY - EXT

Case #: 00541330

 
Footcandles calculated at grade

Filename: POP-230217WENYCJW.A

Layout By:
Collin Witherow

Date: 2/17/2023

Scale 1" = 16'



BRETT L. STEENBURGH, P.E. PLLC

2832 Rosendale Road
Niskayuna, NY 12309
(518) 365-0675



(518) 365-0675
bsteenburgh@gmail.com

**ENGINEERING THAT TRANSFORMS
IMAGINATION INTO REALITY**

LIGHTING PLAN

LIBERTY RESTAURANTS

LIBERTY RESTAURANTS

TOWN OF WEBSTER

BY:	COAL F.
STATE OF NEW YORK	

DATE: OCTOBER 17, 2007 SHEET | -1

DATE: OCTOBER 17 2007

Scaling off these drawings shall be done only for review and approval purposes. Contractors shall use dimensions and electronic data only for layout and construction.

Unauthorized alterations or additions to
this document is a violation of Sec. 7209
Sub. 2. of the NYS Education Law.
Copyright 2021 Brett L. Steenburgh, P.E., PLLC
All right reserved. No use or reproduction
of this material is permitted without the
express written consent of Brett L.
Steenburgh, P.E., PLLC

